


Firm Registration  
 No. 12000

ISSUED:

REVISIONS:

▲ CITY COMMENTS

PROJECT INFO:

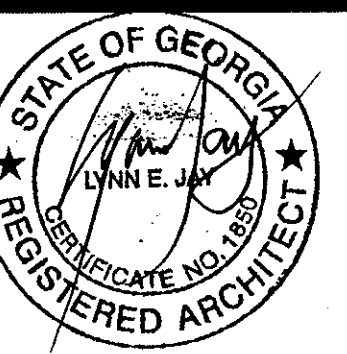


REJOICE IN THE WORD CHURCH INTERNATIONAL MINISTRY  
 P.O. BOX 165 SNELLVILLE  
 GA 30078

DRAWN: ADI CHECKED: DA  
 JOB NO: 012010

FIRST FLOOR  
 PLAN

SHEET:

**AE-100**

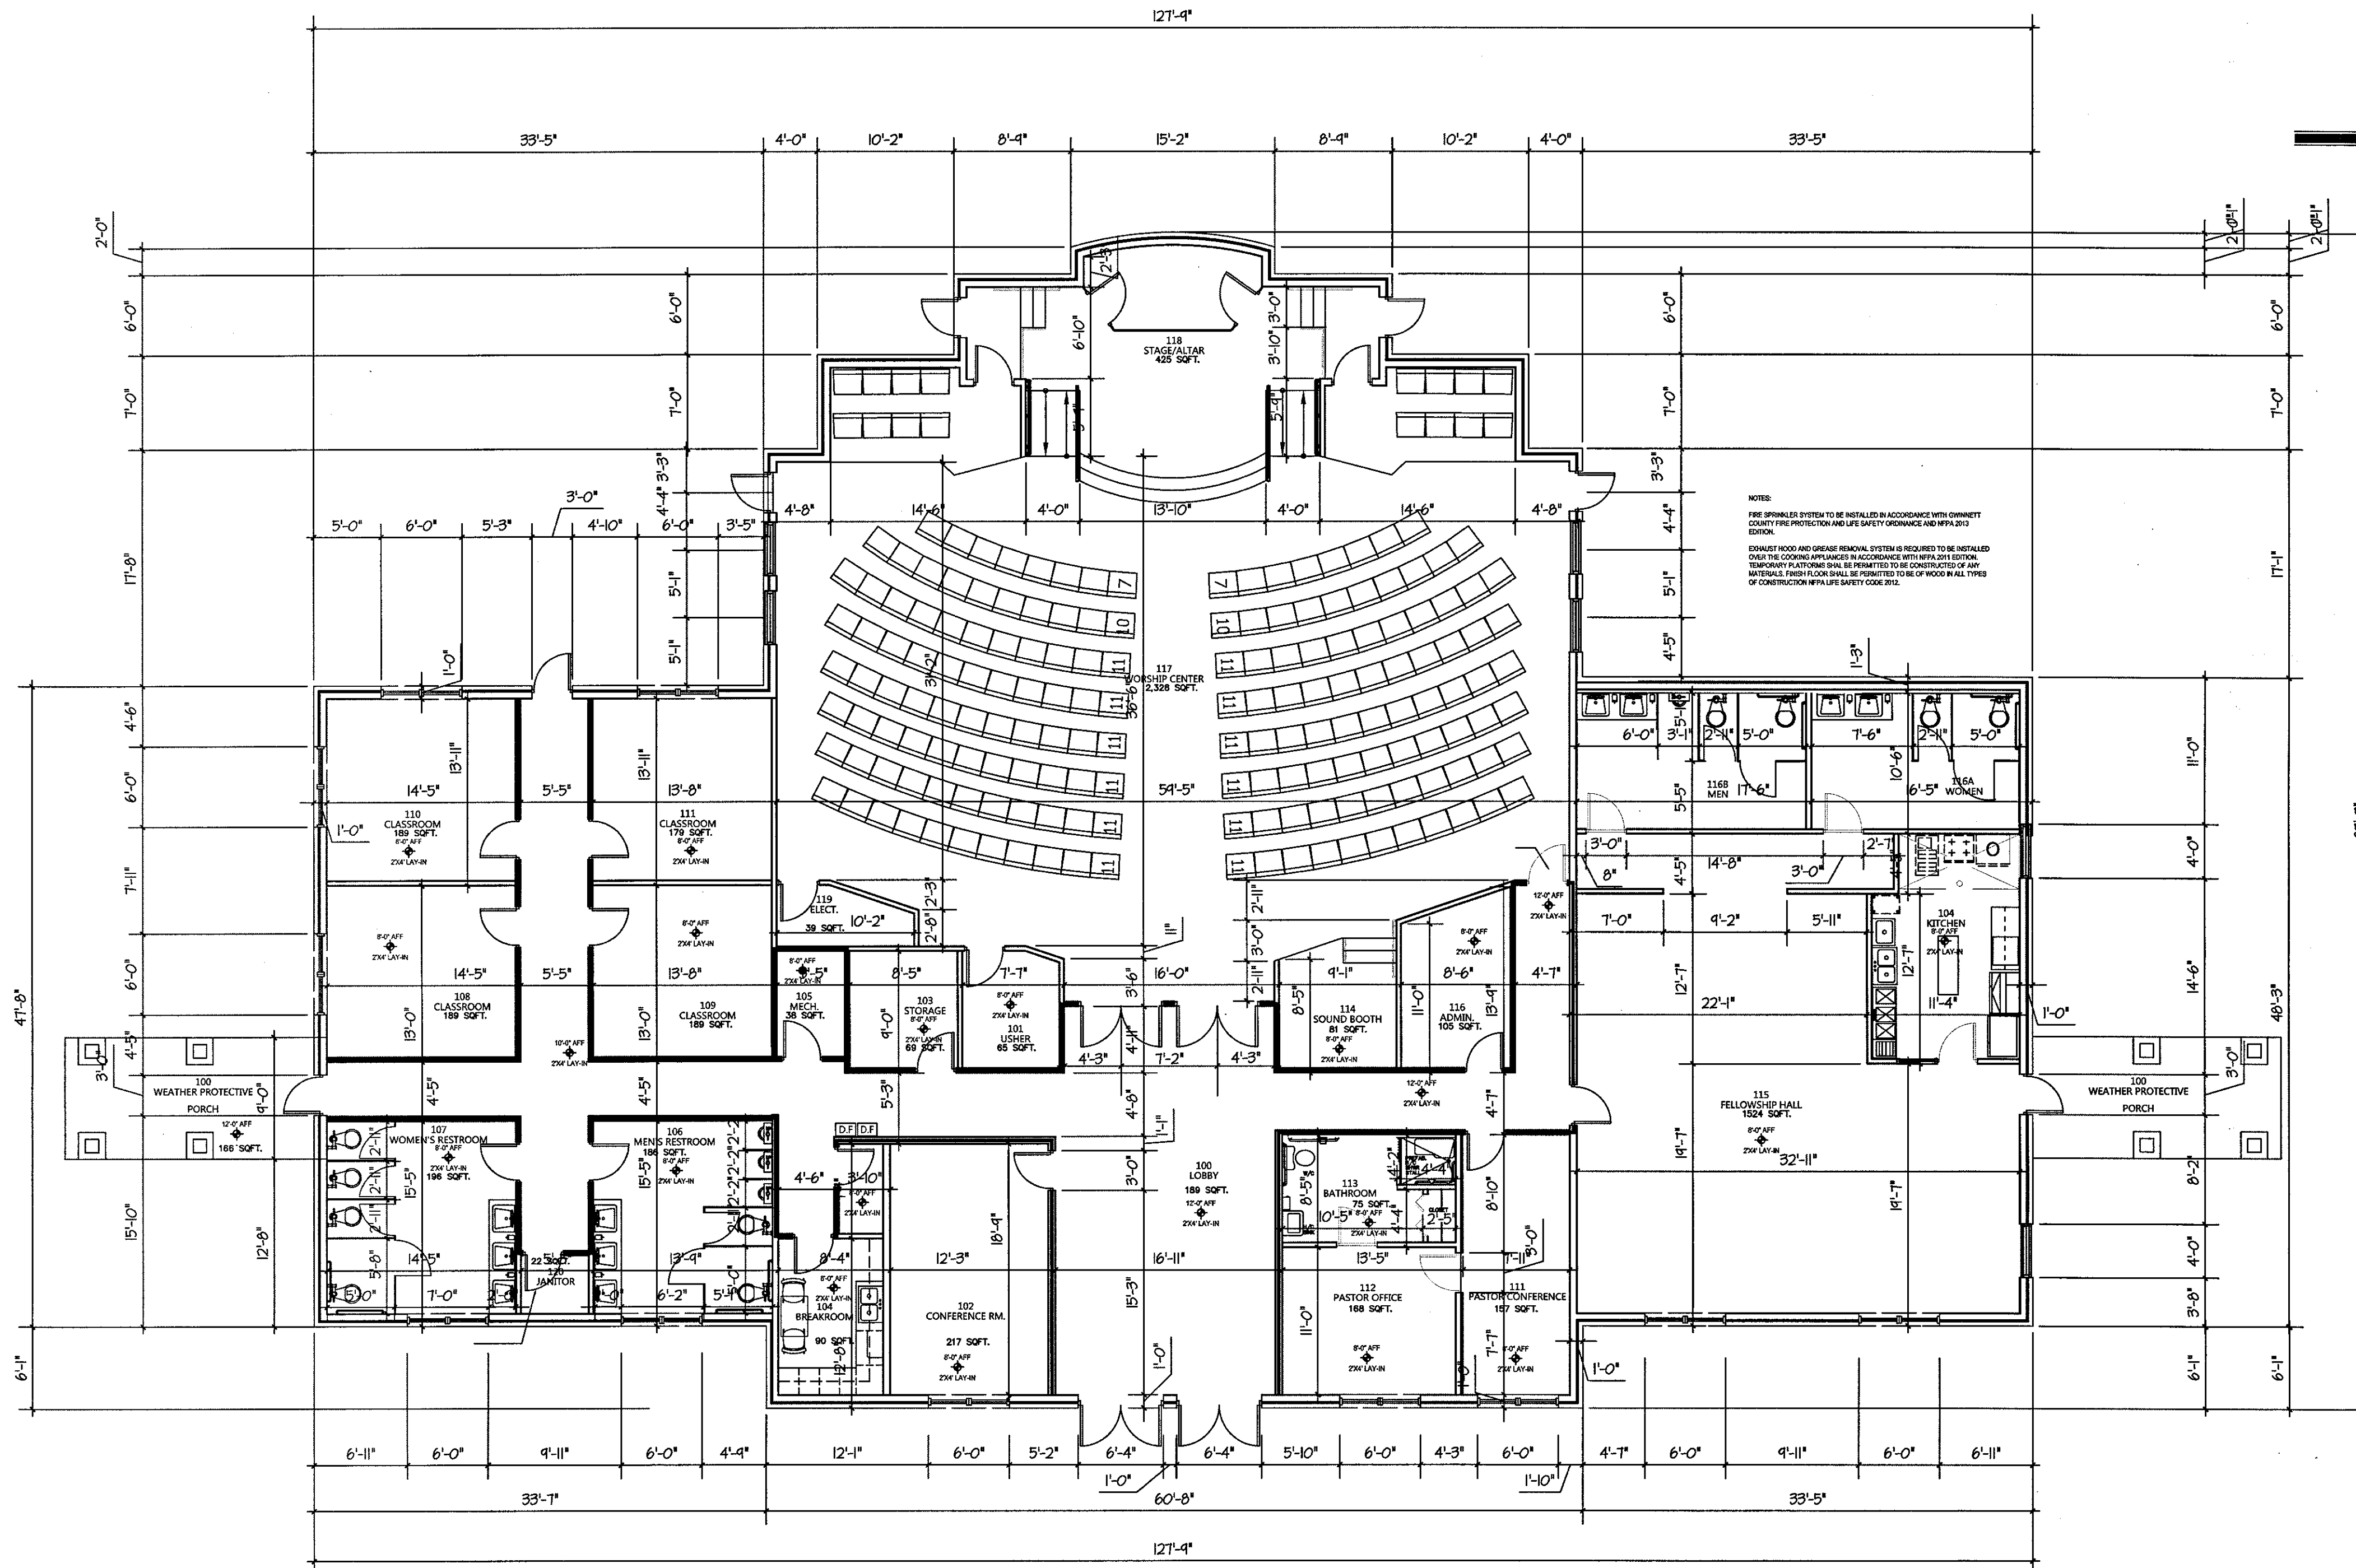

2 HOUR RATED UL#1465 GYPSUM BOARD, UL#905 CMU, AND UL#442 CEMENT BOARD  
 Note:  
 1 HR FIRE AND SMOKE BARRIER  
 PROTECT ALL OPENINGS. (BY GC)

NOTES:  
 FIRE SPRINKLER SYSTEM TO BE INSTALLED IN ACCORDANCE WITH OWNERS COUNTY FIRE PROTECTION AND LIFE SAFETY ORDINANCE AND NFPA 1313 EDITION.  
 EXHAUST HOOD AND GREASE REMOVAL SYSTEM IS REQUIRED TO BE INSTALLED OVER THE COOKING APPLIANCE IN ACCORDANCE WITH NFPA 96 EDITION. TEMPORARY PLUMBING SHALL BE PERMITTED TO BE CONSTRUCTED OF ANY MATERIALS PROVIDED THAT THE PERMITTED TYPE OF WORK IN ALL TYPES OF CONSTRUCTION NFPA LIFE SAFETY CODE 914.

**01** DIMENSIONED FLOOR PLAN  
 AE-100 SCALE: 1/8" = 1' 0"