

FEB 05 2021

EDISON BASE PLAN

CITY OF SNELLVILLE
PLANNING & DEVELOPMENT

Sheet Number	Sheet Name
A0.0.0	COVER SHEET
A0.0.2	GENERAL NOTES
A1.0.0	FRONT & LEFT ELEVATION - A
A1.0.1	REAR & RIGHT ELEVATION - A
A1.0.2	ROOF PLAN - A
A1.1.0	SLAB FOUNDATION PLAN - A
A1.2.0	FIRST FLOOR PLAN - A
A2.0.0	FRONT & LEFT ELEVATION - B
A2.0.1	REAR & RIGHT ELEVATION - B
A2.0.4	ROOF PLAN - B
A2.1.0	SLAB FOUNDATION PLAN - B
A2.2.0	FIRST FLOOR PLAN - B
A3.0.0	FRONT & LEFT ELEVATION - C
A3.0.1	REAR & RIGHT ELEVATION - C
A3.0.4	ROOF PLAN - C
A3.1.0	SLAB FOUNDATION PLAN - C
A3.2.0	FIRST FLOOR PLAN - C
A4.0.0	FRONT & LEFT ELEVATION - D
A4.0.1	REAR & RIGHT ELEVATION - D
A4.0.2	ROOF PLAN - D
A4.1.0	SLAB FOUNDATION PLAN - D
A4.2.0	FIRST FLOOR PLAN - D
AD1.0.0	BASEMENT FOUNDATION PLAN
AD1.0.1	OPTIONS
AD1.0.2	OPTIONS
AD1.0.3	OPTIONS
AD1.0.4	OPTIONS
AD1.0.5	OPTIONS
AD1.0.6	OPTIONS
E1.0.0	BASEMENT ELECTRICAL PLAN
E1.1.0	FIRST FLOOR ELEC. PLAN - A
E2.1.0	FIRST FLOOR ELEC. PLAN - B
E3.1.0	FIRST FLOOR ELEC. PLAN - C
E4.1.0	FIRST FLOOR ELEC. PLAN - D
HD1.0.0	OPTIONS
HD1.0.1	OPTIONS

[illegible]

1. 2018 INTERNATIONAL RESIDENTIAL CODE, WITH 2018 GEORGIA AMENDMENTS.
2. NATIONAL DESIGN SPECIFICATION FOR WOOD CONSTRUCTION.
3. ACI 318, BUILDING CODE FOR REINFORCED CONCRETE.
4. A.I.S.C. MANUAL OF STEEL CONSTRUCTION
5. T.F.I. SPECIFICATION FOR THE DESIGN, MANUFACTURE AND HANDLING OF WOOD TRUSSES.

AREA	SQ. FT.
First Floor - A	1783 SF
TOTAL - A - HEATED	1783 SF
2-Car Garage - A	433 SF
Front Covered Porch - A	207 SF
Rear Covered Patio - A	120 SF
TOTAL - A - UNHEATED	760 SF
First Floor - B	1783 SF
TOTAL - B - HEATED	1783 SF
2-Car Garage - B	433 SF
Front Covered Porch - B	207 SF
Rear Covered Patio - B	120 SF
TOTAL - B - UNHEATED	760 SF
First Floor - C	1783 SF
TOTAL - C - HEATED	1783 SF
2-Car Garage - C	433 SF
Front Covered Porch - C	207 SF
Rear Covered Patio - C	120 SF
TOTAL - C - UNHEATED	760 SF
First Floor - D	1783 SF
TOTAL - D - HEATED	1783 SF
2-Car Garage - D	433 SF
Front Covered Porch - D	207 SF
Rear Covered Patio - D	120 SF
TOTAL - D - UNHEATED	760 SF
Unfinished Basement	1802 SF
TOTAL - OPTIONAL UNHEATED	1802 SF

[illegible]

Elevation Code: -
Foundation: Slab
Drive Side: LH

Project Name (Base Plans/Residence):

BASE PLAN

Neighborhood/Lot #:
LOT # 4 COMMUNITY

Plan Name: EDISON

AS NOTED
Created Date:
08/09/17
Plot Date:
05/15/20
Drawn by:
Matt Shelton


COVER SHEET

PATRICK MALLOY
C O M M U N I T I E S
4770 S. ATLANTA RD., 5TE. 100, ATLANTA, GA 30339 770.932.6376

SHEET:

AO.O.O

PLOTTED DATE/TIME: 6/18/2020 11:52:10 AM

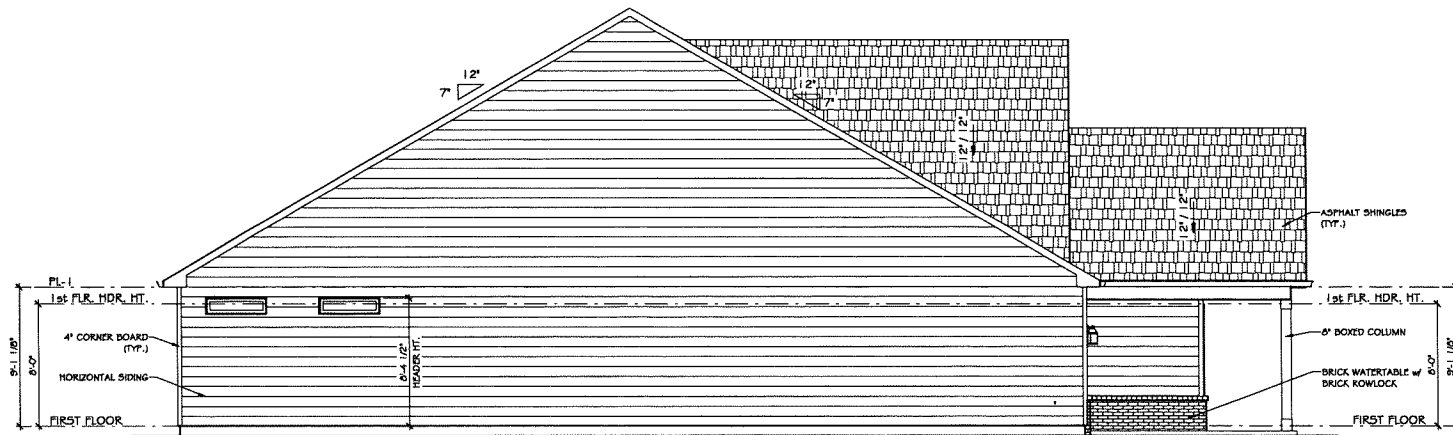

② LEFT ELEVATION - A
1/8" = 1'-0"



① FRONT ELEVATION - A
1/8" = 1'-0"

Revisions:	
DATE	REMARKS

Project Name (Base Plan/Reference):	BASE PLAN
Neighborhood #:	LOT # COMMUNITY
Plan Name:	EDISON
Elevation Code:	Slab
Foundation:	LI
Drive Side:	


Plot Scale:	AS NOTED
Created Date:	08/09/17
Plot Date:	05/15/20
Drawn by:	Matt Shelton

FRONT & LEFT ELEVATION - A	PATRICK MALLOY
	COMMUNITIES
	4770 S. ATLANTA RD., STE. 100, ATLANTA, GA 30339 770.632.6376
	SHEET:
	AI.O.O

VPatrick Malloy/Slab/Edison/Left/Right/First/Edison.vt



② RIGHT ELEVATION - A
1/8" = 1'-0"

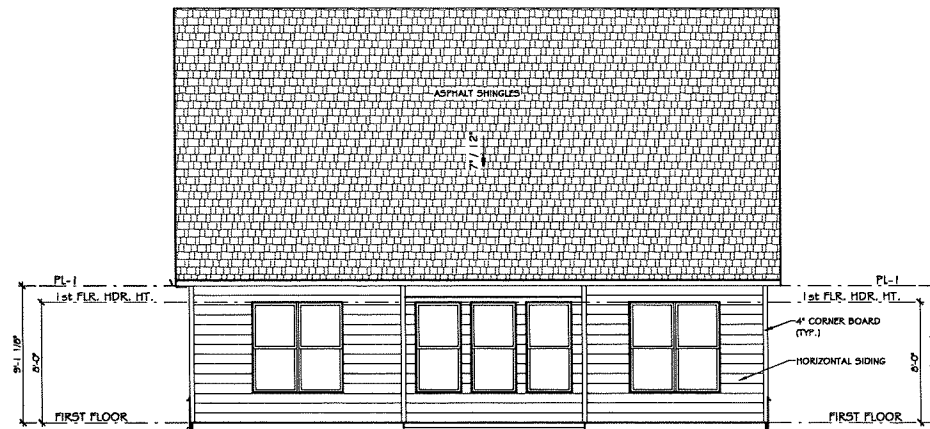

① REAR ELEVATION - A
1/8" = 1'-0"


Revisions:		
#	DATE	REMARKS

Project Name: (Base Plan/Residence):	
BASE PLAN	
Elevation Code: -	Slab
Foundation: -	LH
Drive Side: -	DRIVE SIDE
Neighborhood: #:	
LOT # COMMUNITY	
Plan Name: EDISON	

Plot Scale:	AS NOTED
Created Date:	08/09/17
Plot Date:	05/15/20
Drawn by:	Matt Shelton

REAR & RIGHT ELEVATION - A	
PATRICK MALLOY	
COMMUNITIES	
4770 S. ATLANTA RD., STE. 100, ATLANTA, GA 30339 770.435.6376	

SHEET:	A1.0.1
--------	---------------

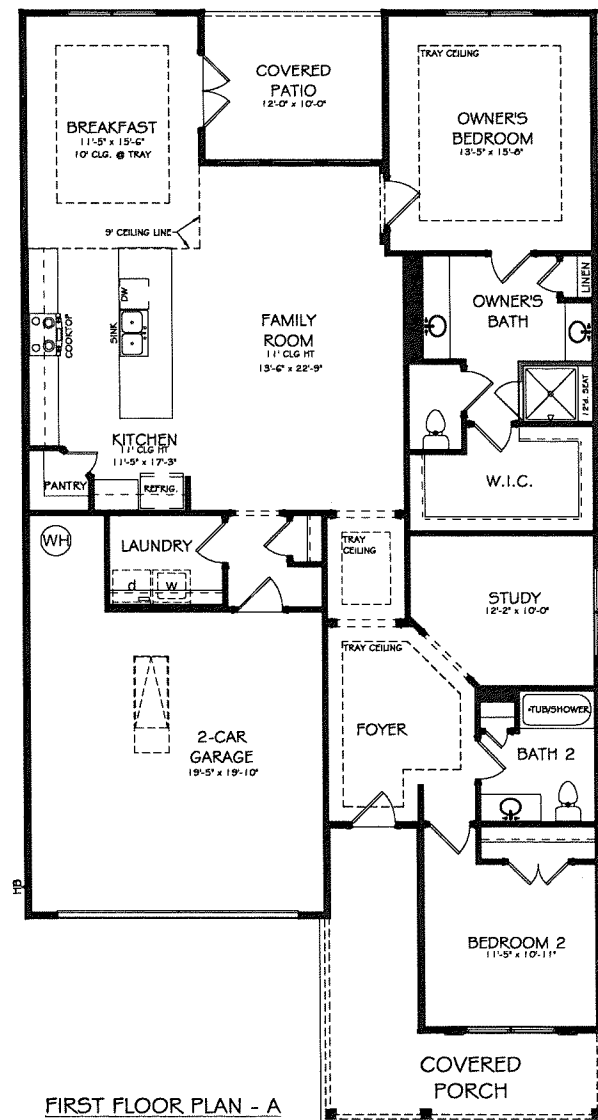

FIRST FLOOR PLAN - A

[illegible]

Project Name (Base Plans/Residence):

Project Name (Base Plan)
BASE PLAN

Neighborhood #1:

Neighborhood/Lot #:

Plan Name: EDISON


Plot Scale:
AS NOTED
Created Date:
08/09/17
Plot Date:
05/15/20
Drawn by:
Matt Shelto

1ST FLOOR - A

PATRICK MALLOY
COMMUNITIES

SHEET:

H1.O.1

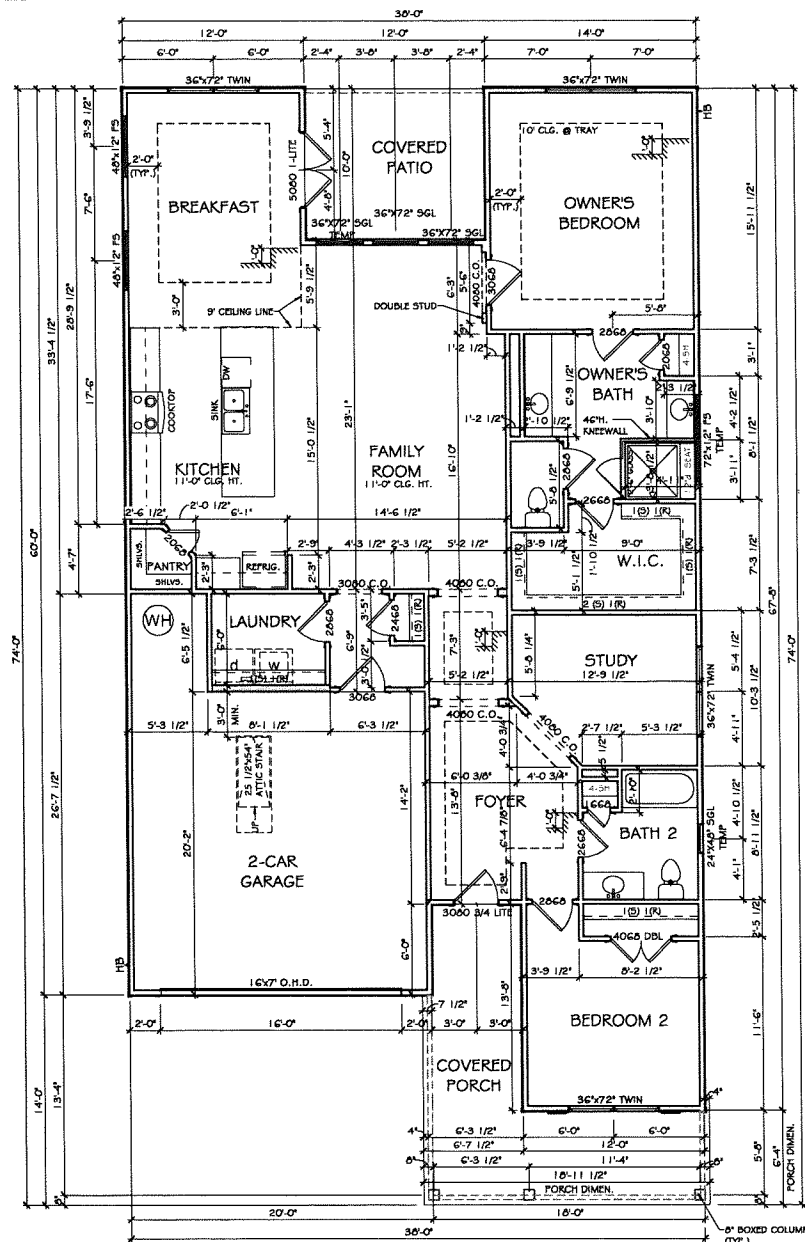

① First Floor Plan - A
1/8" = 1'-0"

WALL LEGEND	
	2x4 EXT. WALL w/ BRICK
	2x4 EXT. WALL w/ SIDING
	2x4 INT. WALL
	2x4 INT. KNEE WALL
	2x4 INT. DOUBLE WALL
	2x6 EXT. WALL w/ BRICK
	2x6 EXT. WALL w/ SIDING
	2x6 INT. WALL
	BASEMENT- 8" POURED CONC.
	BASEMENT- 8" POURED CONC. w/ BRICK

*Exterior Cladding per Neighborhood Specification

[illegible]

Project Name (Base Plans/Residence):

Project Name (D&E Plans)
BASE PLAN

Neighborhood/lot #:

Neighborhood/Lot #: LOT # & COMMUNITY

Plan Name: EDISON

Plot Scale:
AS NOTED
Created Date:
08/09/17
Plot Date:
03/02/20

Drawn by:
Matt Shelton


FIRST FLOOR PLAN - A

PATRICK MALLOY
C O M M U N I T I E S
4770 S. ATLANTA RD., 3RD FLOOR, ATLANTA, GA 30339 770.332.6376

SHEET:

A1.2.0

PLOTTED DATE/TIME: 6/18/2020 12:02:15 PM

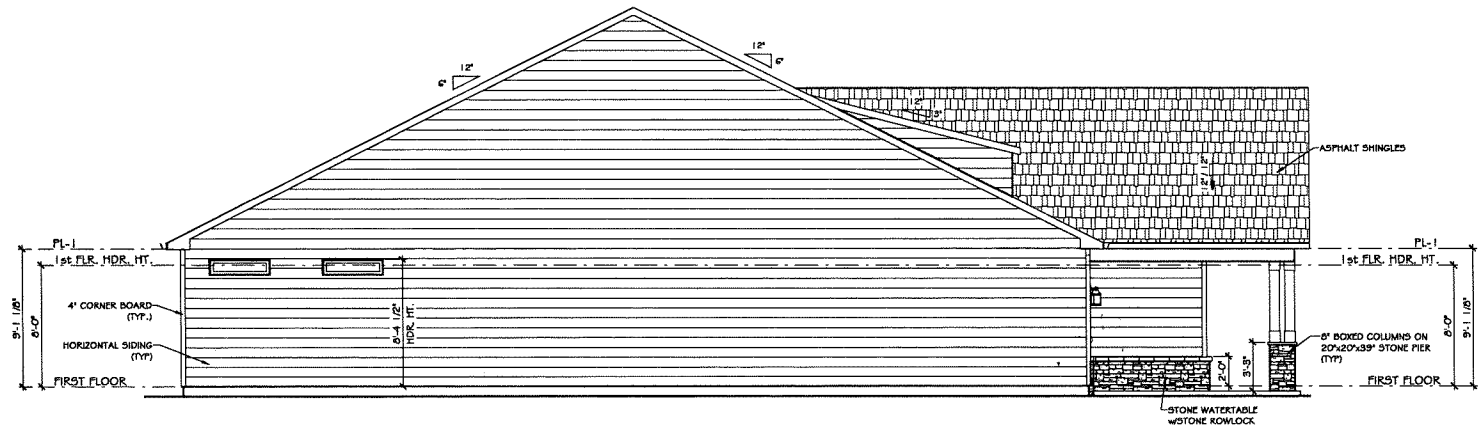

② LEFT ELEVATION - B
1/8" = 1'-0"



① FRONT ELEVATION - B
1/8" = 1'-0"

Revisions:	
#	DATE REMARKS
1	
2	
3	
4	
5	
6	
7	
8	
9	
10	


Project Name (Base Plan/Reference):	
BASE PLAN	
Elevation Code:	Slab LH
Foundation:	LI
Drive Side:	LI
Neighborhood/Lot #:	LOT # COMMUNITY
Plan Name:	EDISON

Plot Scale:	AS NOTED
Created Date:	08/09/17
Plot Date:	05/15/20
Drawn by:	Matt Shelton

FRONT & LEFT ELEVATION - B	PATRICK MALLOY COMMUNITIES 4770 S. ATLANTA RD., STE. 100, ATLANTA, GA 30339 770.632.6276

SHEET:
A2.0.0

1. LOTTED DATE/TIME: 6/18/2025 12:42:57 PM

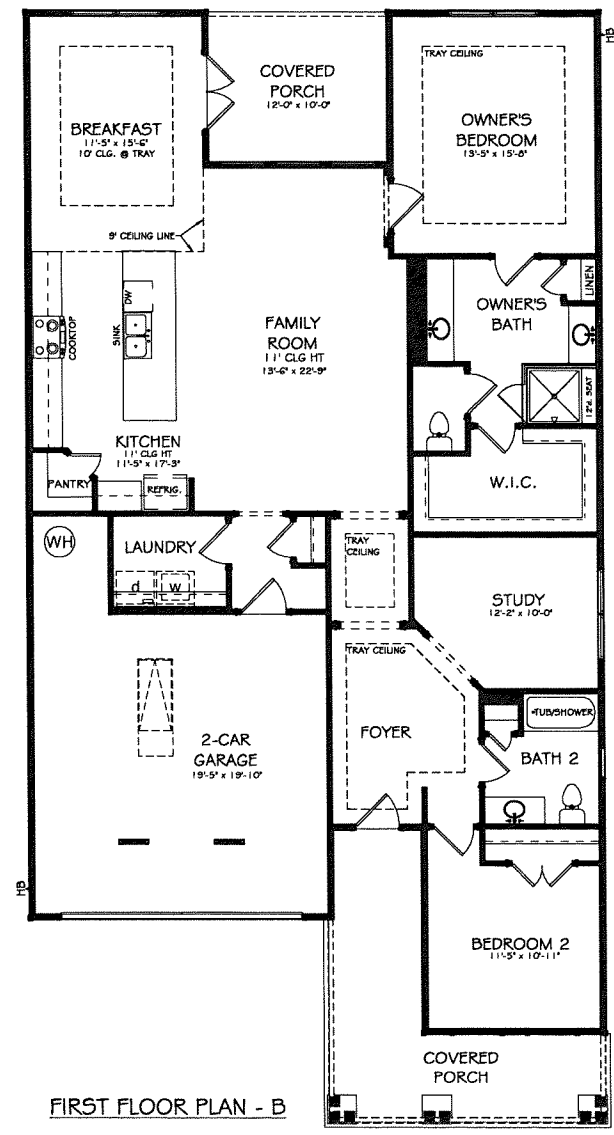

1ST FLOOR - B

PATRICK MALLOY
COMMUNITIES
4770 S. ATLANTA RD., STE. 100, ATLANTA, GA 30339 770.432.6376

SHEET:
H2.O.1

Project Name (Base Plan/Residence):
BASE PLAN

Neighborhood Lot #:
LOT # COMMUNITY

Plan Name:
EDISON

Plot Scale:
AS NOTED

Created Date:
08/09/17

Plot Date:
05/15/20


Drawn by:
Matt Shelton

Revisions:

#	DATE	REMARKS

Elevation Code: Slab
Foundation: L1
Drive Side:

V:\Master Plans\Water Resilience\EDITION1\FloorPlans.dwg

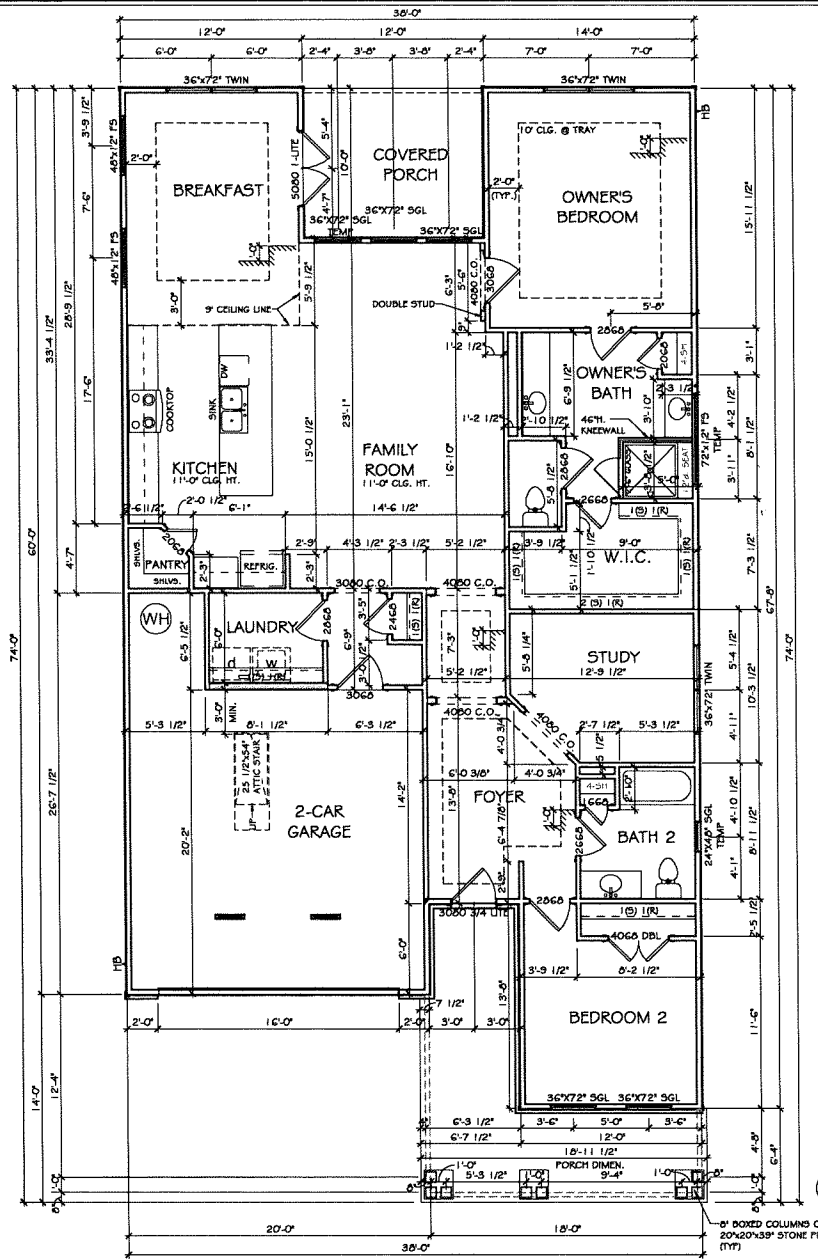

① First Floor Plan - B
1/8" = 1'-0"

WALL LEGEND	
	2x4 EXT. WALL w/ BRICK
	2x4 EXT. WALL w/ SIDING
	2x4 INT. WALL
	2x4 INT. KNEE WALL
	2x4 INT. DOUBLE WALL
	2x6 EXT. WALL w/ BRICK
	2x6 EXT. WALL w/ SIDING
	2x6 INT. WALL
	BASEMENT - 6\"/>
	BASEMENT - 6\"/>
	BASEMENT - 6\"/>

*Exterior Cladding per Neighborhood Specification

[illegible]

Project Name (Base Plans/Residence):

Project Name (Base Plan) BASE PLAN

Neighborhood/Lot #:

Neighborhood/Lot #:
LOT # & COMMUNITY

Plan Name: EDISON


Plot Scale:
AS NOTED
Created Date:
08/09/17
Plot Date:
03/02/20
Drawn by:
Matt Shelton

FIRST FLOOR PLAN - B

PATRICK MALLOY
COMMUNITIES

SHEET:

A2.2.0

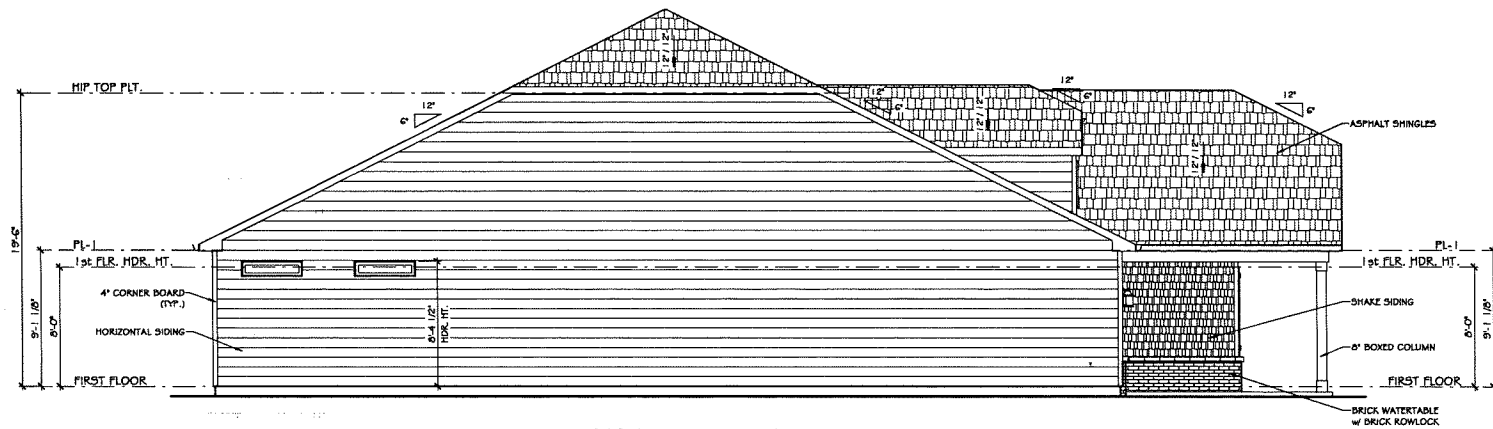

② LEFT ELEVATION - C
1/8" = 1'-0"



① FRONT ELEVATION - C
1/8" = 1'-0"

Revisions:

#	DATE	REMARKS

Elevation Code: Slab
Foundation: LH
Drive Side: LH
Neighborhood/Lot #: 4770 S. ATLANTA RD., STE. 100, ATLANTA, GA 30339 770.632.6376

BASE PLAN

Neighborhood/Lot #: 4770 S. ATLANTA RD., STE. 100, ATLANTA, GA 30339 770.632.6376

Plan Name: EDISON

Plot Scale:

A5 NOTED

Created Date: 08/09/17

Plot Date: 05/15/20


Drawn by: Matt Shelton

FRONT & LEFT ELEVATION - C


PATRICK MALLOY
COMMUNITIES
4770 S. ATLANTA RD., STE. 100, ATLANTA, GA 30339 770.632.6376

SHEET:

A3.0.0

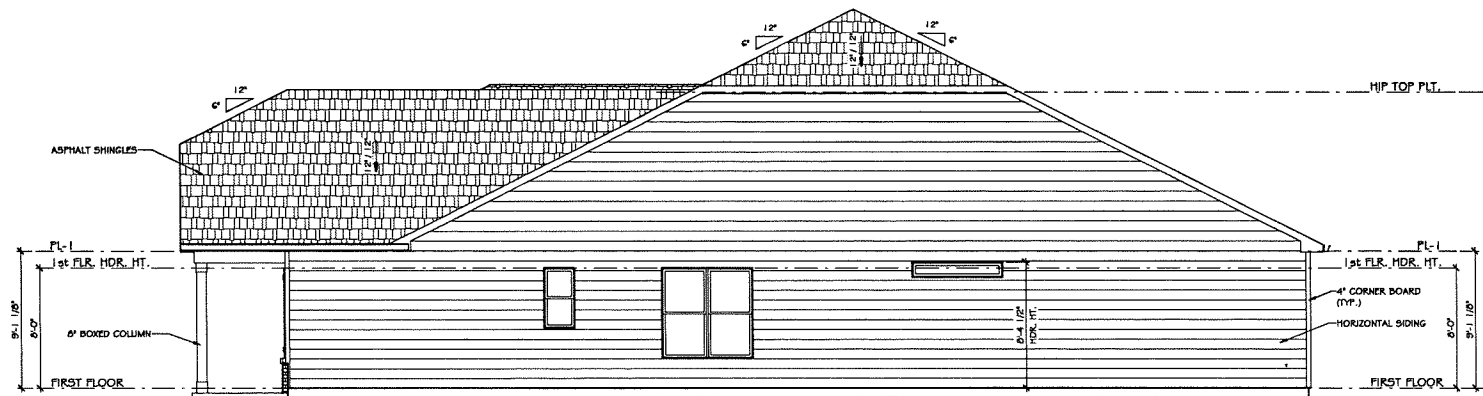

② RIGHT ELEVATION - C
1/8" = 1'-0"

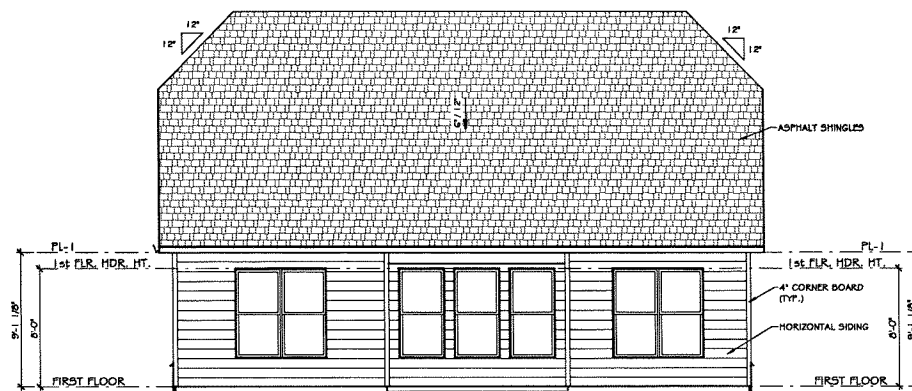

① REAR ELEVATION - C
1/8" = 1'-0"

[illegible]

Project Name (Base Plans/Residence):

BASE PLAN

Neighborhood/Lot #:

LOT # & COMMUNITY

Plan Name: EDISON

Plot Scale:
AS NOTED

Created Date:
08/09/17

Plot Date:
05/15/20

Drawn by:
Matt Shelton


REAR & RIGHT ELEVATION - C

PATRICK MALLOY

COMMUNITIES
7770 S. ATLANTA RD., STE. 100, ATLANTA, GA 30339 770.632.6376

SHEET:

A3.0.1

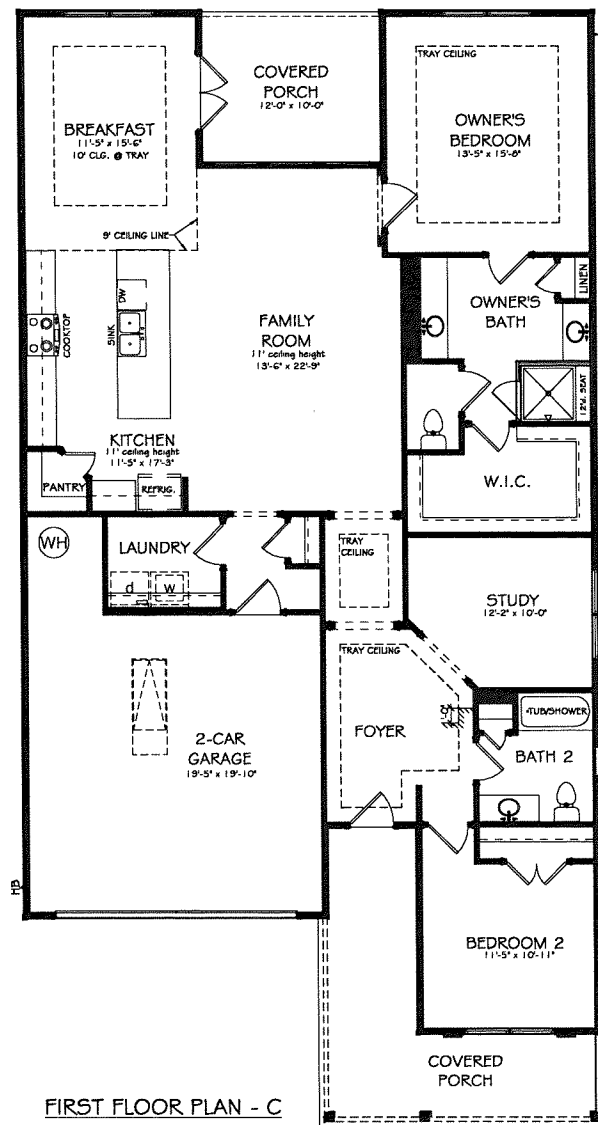

FIRST FLOOR PLAN - C

[illegible]

Project Name (Base Plans/Residence):

Project Name (Base Plans)

BASE PLAN

Neighborhood/Lot #:

Neighborhood/Lot #:
LOT # & COMMUNITY

Plan Name: EDISON


Plot Scale:
6 NOTED
Created Date:
8/09/17
Plot Date:
5/15/20
Drawn by:
tt Shelto

1ST FLOOR - C

PATRICK MALLOY
C O M M U N I T I E S
2720 S. ATLANTA RD. SUITE 100 ATLANTA, GA 30339 770.432.6376

SHEET:

H3.0.1

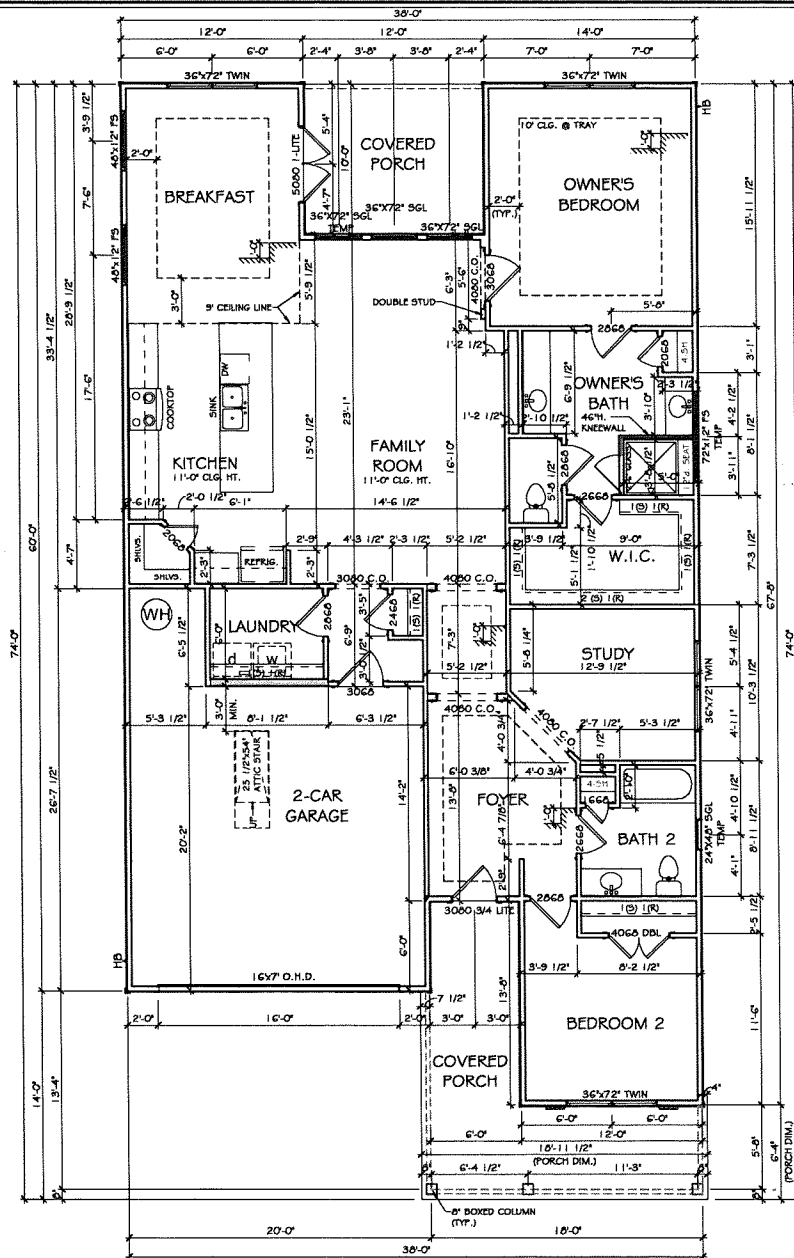

WALL LEGEND	
	2x4 EXT. WALL w/ BRICK
	2x4 EXT. WALL w/ SIDING
	2x4 INT. WALL
	2x4 INT. KNEE WALL
	2x4 INT. DOUBLE WALL
	2x6 EXT. WALL w/ BRICK
	2x6 EXT. WALL w/ SIDING
	2x6 INT. WALL
	BASEMENT- 8" POURED CON
	BASEMENT- 8" POURED
	CONC. w/ BRICK

*Exterior Cladding per Neighborhood Specification

[illegible]

Project Name (Base Plans/Residence):

Project Name (Base Plan) BASE PLAN

Neighborhood/Lot #: LOT # 4 COMMUNITY
Plan Name: FDISO

Plan Name: FDISON

Plot Scale:
AS NOTED
Created Date:
08/09/17
Plot Date:
10/11/19
Drawn by:
Matt Shelton


FIRST FLOOR PLAN - C

PATRICK MALLOY
COMMUNITIES

SHEET:

A3.2.0

① First Floor Plan - C
1/8" = 1'-0"

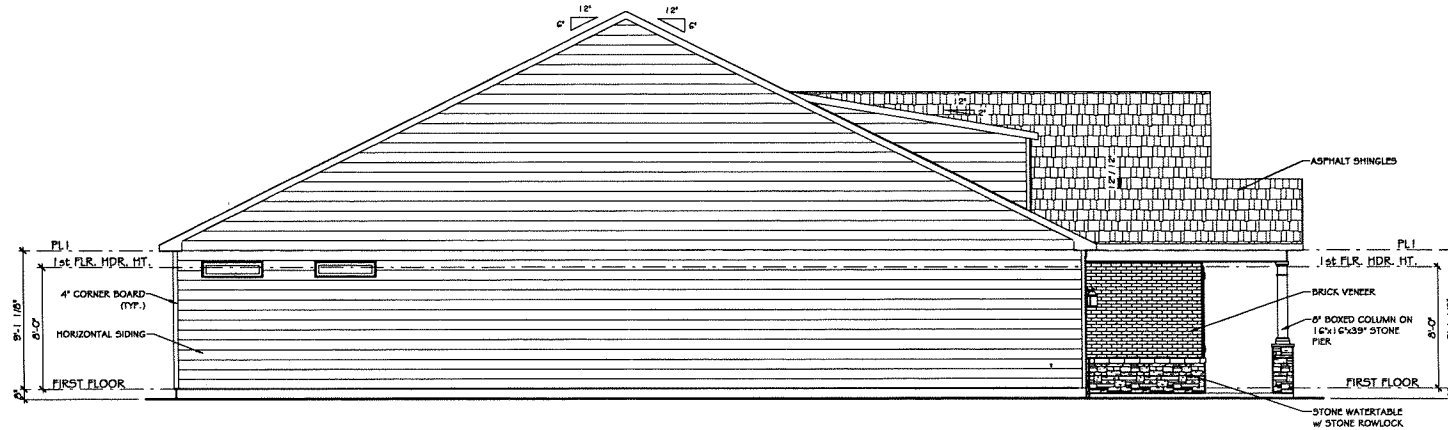

② LEFT ELEVATION - D
1/8" = 1'-0"



① FRONT ELEVATION - D
1/8" = 1'-0"

Revisions:		
#	DATE	REMARKS

Elevation Code: Slab LH
Foundation: LH
Drive Side: LH

Project Name (Base Plan/Revision):

BASE PLAN

Neighborhood Lot #:

LOT # COMMUNITY

Plan Name: EDISON


Plot Scale: AS NOTED
Created Date: 08/09/17
Plot Date: 05/15/20
Drawn by: Matt Shelton

FRONT & LEFT ELEVATION - D


PATRICK MALLOY
COMMUNITIES
4770 S. ATLANTA RD., STE. 100, ATLANTA, GA 30339 770.632.6376

SHEET:

A4.0.0

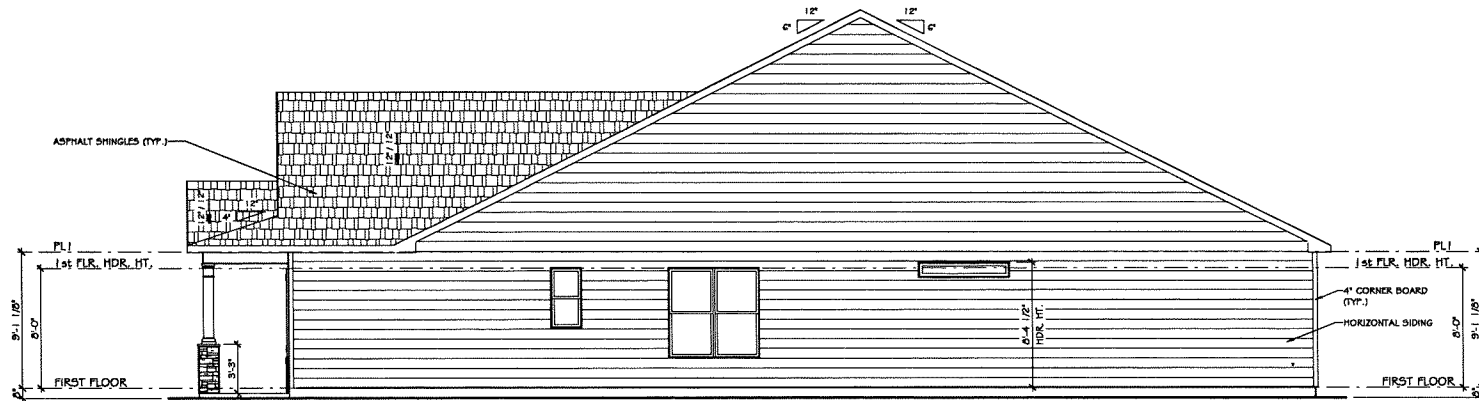

② RIGHT ELEVATION - D
1/8" = 1'-0"

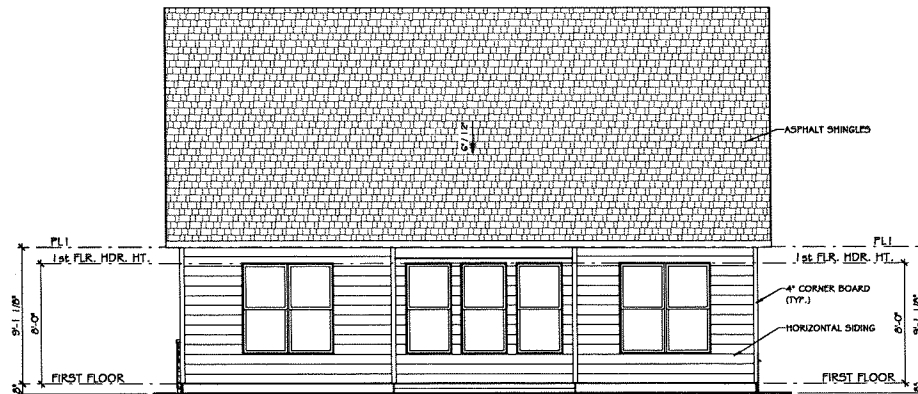

① REAR ELEVATION - D
1/8" = 1'-0"

Revisions:		
#	DATE	REMARKS


Project Name (Base Plans/Revisions):	
BASE PLAN	
Elevation Code: -	Slab
Foundation:	LH
Drive Side:	
Neighborhood/Lot #:	
LOT # COMMUNITY	
Plan Name:	EDISON

Plot Scale:	AS NOTED
Created Date:	08/09/17
Plot Date:	05/15/20
Drawn by:	Matt Shelton

REAR & RIGHT ELEVATION - D	PATRICK MALLOY
	COMMUNITIES
	4770 S. ATLANTA RD., STE. 100, ATLANTA, GA 30339 770.632.6376

SHEET:	A4.0.1
--------	--------

PLOTTED DATE/TIME: 01/10/2022 11:03:10 AM

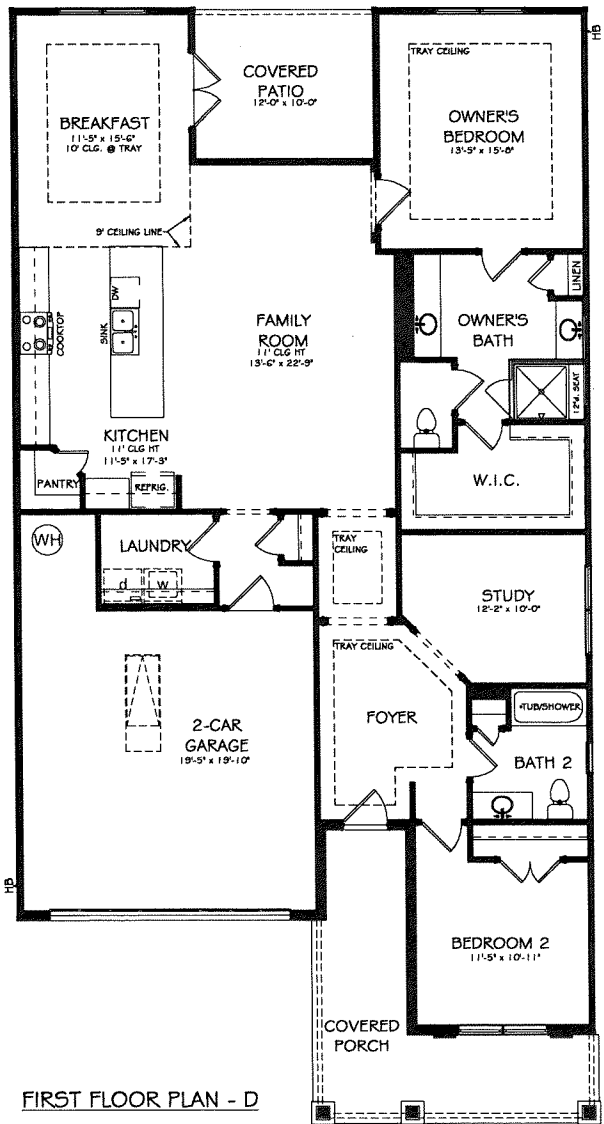

FIRST FLOOR PLAN - D

Revisions:	
#	DATE

Project Name (Base Plans/Residence):	
BASE PLAN	
Neighborhood/Lot #:	
LOT # COMMUNITY	
Plan Name:	
EDISON	
Elevation Code:	Slab LH
Foundation:	LI
Drive Side:	LI


Plot Scale:	AS NOTED
Created Date:	08/09/17
Plot Date:	05/15/20
Drawn by:	Matt Shelton

1ST FLOOR - D

PATRICK MALLOY
COMMUNITIES
4770 S. ATLANTA RD., STE. 100, ATLANTA, GA 30339 770.632.6376

SHEET:
H4.O.1

V:\Water Plans\Edison Plans\Edison.dwg

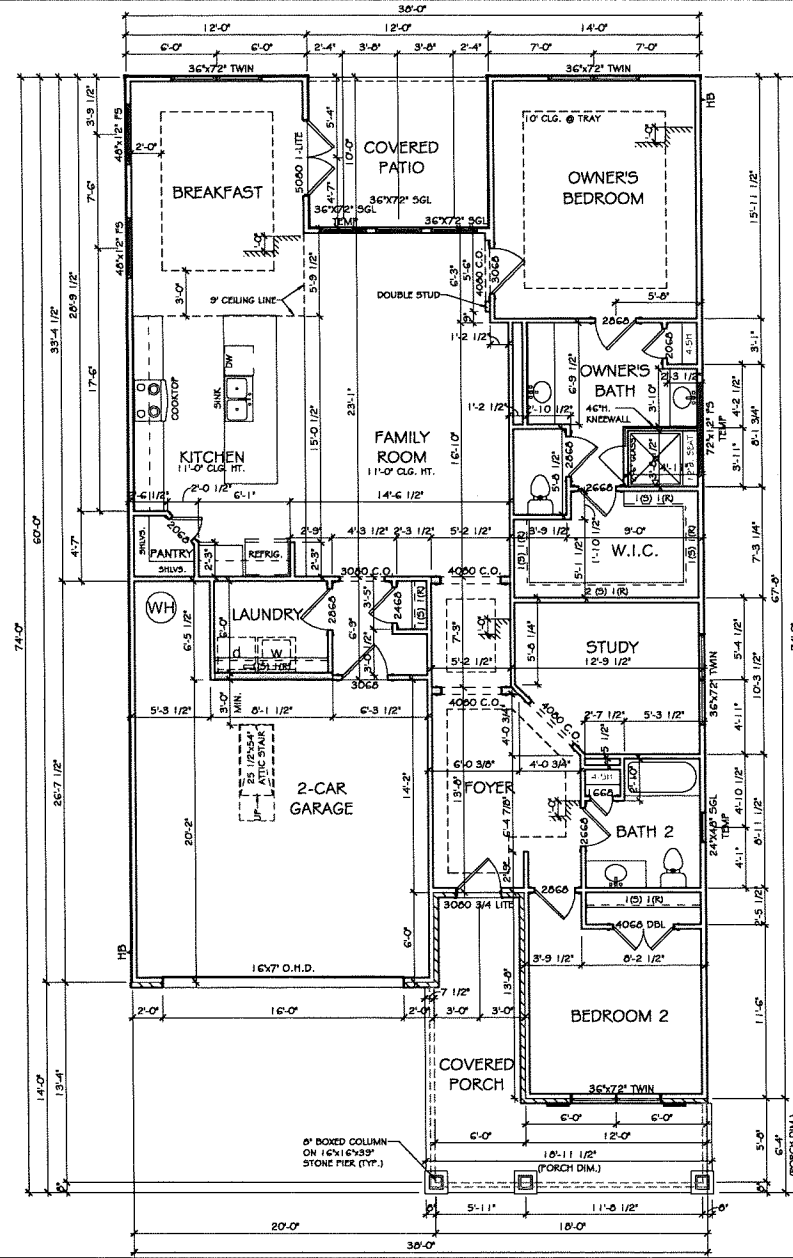

WALL LEGEND	
	2x4 EXT. WALL w/ BRICK
	2x4 EXT. WALL w/ SIDING
	2x4 INT. WALL
	2x4 INT. KNEE WALL
	2x4 INT. DOUBLE WALL
	2x6 EXT. WALL w/ BRICK
	2x6 EXT. WALL w/ SIDING
	2x6 INT. WALL
	BASEMENT- 6\"/>
	BASEMENT- 6\"/>

*Exterior Cladding per Neighborhood Specification

① First Floor Plan - D
1/8" = 1'-0"


Revisions:	
DATE	REMARKS

Project Name: (Base Plan/Residence):	Elevation Code: Slab
Neighborhood/Lot #: LOT # COMMUNITY	Foundation: L1
Plan Name: EDISON	Drawn By: Matt Shelton


Plot Scale: AS NOTED
Created Date: 08/09/17
Plot Date: 03/02/20
Drawn by: Matt Shelton

FIRST FLOOR PLAN - D
PATRICK MALLOY
COMMUNITIES
4770 S. ATLANTA RD., STE. 100, ATLANTA, GA 30339 770.632.6376


SHEET:
A4.2.0

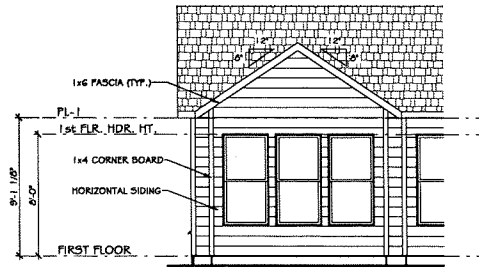


Opt. Owner's Bedroom Bay -
⑤ Rear Elevation
 $1/8" = 1'-0"$

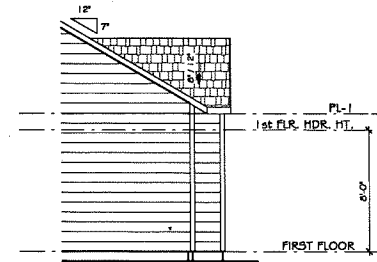


Opt. Owner's Bedroom Bay -
④ Side Elevation
 $1/8" = 1'-0"$

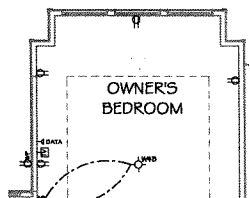

Opt. Owner's Bedroom Bay -
③ Electrical Plan
 $1/8" = 1'-0"$

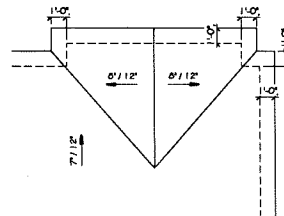

Opt. Owner's Bedroom Bay -
② Roof Plan
 $1/8" = 1'-0"$

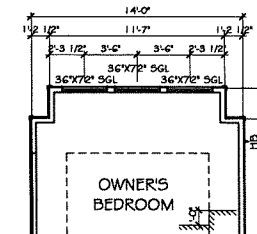

Opt. Owner's Bedroom Bay -
① Floor Plan
 $1/8" = 1'-0"$


Revisions:		
#	DATE	REMARKS
1	05/15/20	ISSUED FOR PERMIT

Project Name (Base Plan/Residence):	
BASE PLAN	
Elevation Code: -	Slab
Foundation:	LH
Driv. Side:	
Neighborhood/lot #:	LOT # COMMUNITY
Plan Name:	EDISON


Plot Scale:	AS NOTED
Created Date:	08/09/17
Plot Date:	05/15/20
Drawn by:	Matt Shelton

OPTIONS	PATRICK MALLOY	COMMUNITIES
4770 S. ATLANTA RD., STE. 100, ATLANTA, GA 30339 770.632.6376		


SHEET:
AD1.0.1

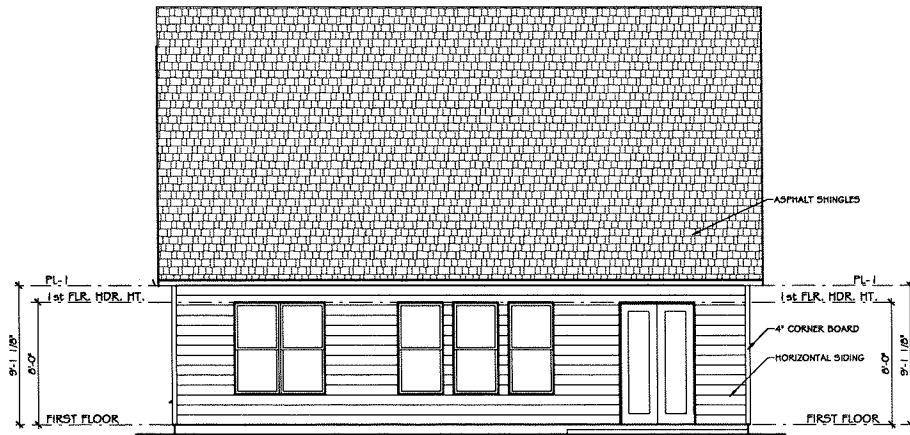


④ Opt. Sunroom - Rear Elevation
1/8" = 1'-0"

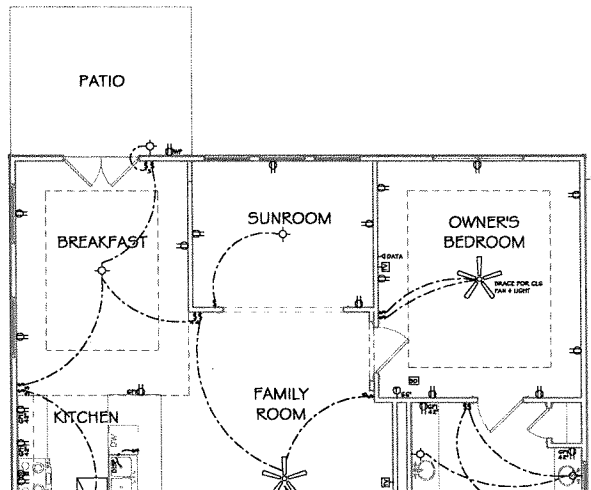

② Opt. Sunroom Electrical Plan
1/8" = 1'-0"

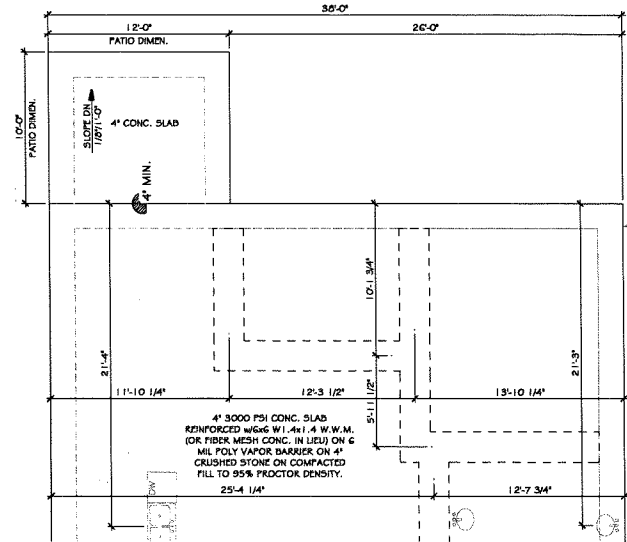

③ Opt. Sunroom - Slab Foundation Plan
1/8" = 1'-0"

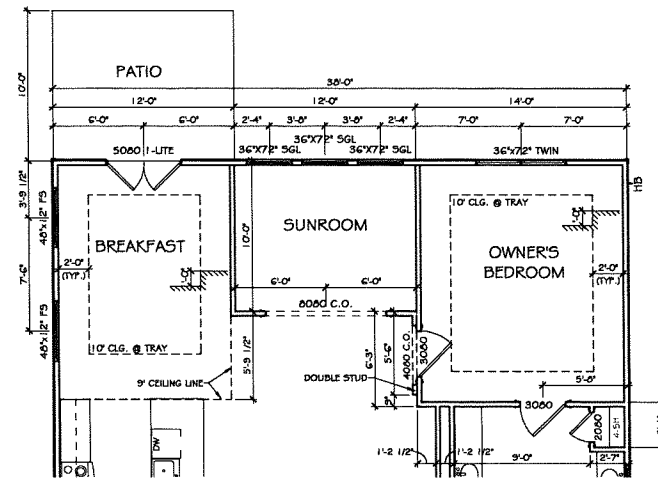


① Opt. Sunroom
1/8" = 1'-0"

Revisions:	
#	DATE


Project Name (Base Plans/Residence):	BASE PLAN
Elevation Code:	Slab
Foundation:	LH
Drive Side:	
Neighborhood Lot #:	LOT # COMMUNITY
Plan Name:	EDISON

Plot Scale:	AS NOTED
Created Date:	08/09/17
Plot Date:	05/15/20
Drawn by:	Matt Shelton

OPTIONS
PATRICK MALLOY
COMMUNITIES
4770 S. ATLANTA RD., STE. 100, ATLANTA, GA 30339 770.632.6376
SHEET:
AD1.0.2

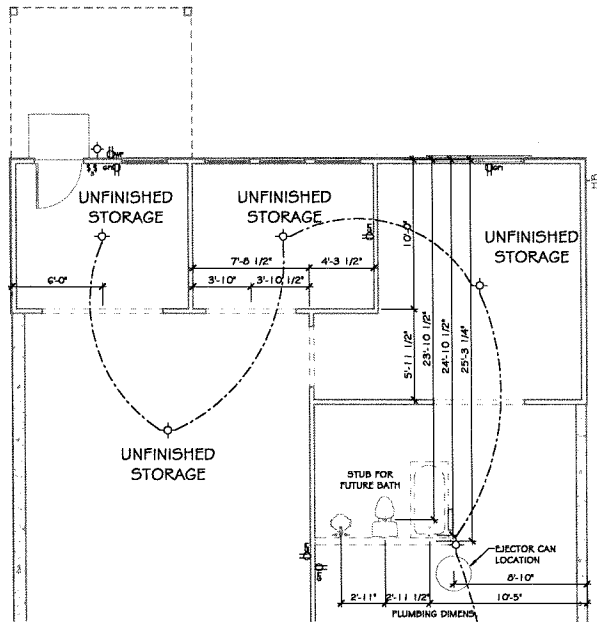

② Opt. Sunroom Bsmt Electrical Plan
1/8" = 1'-0"

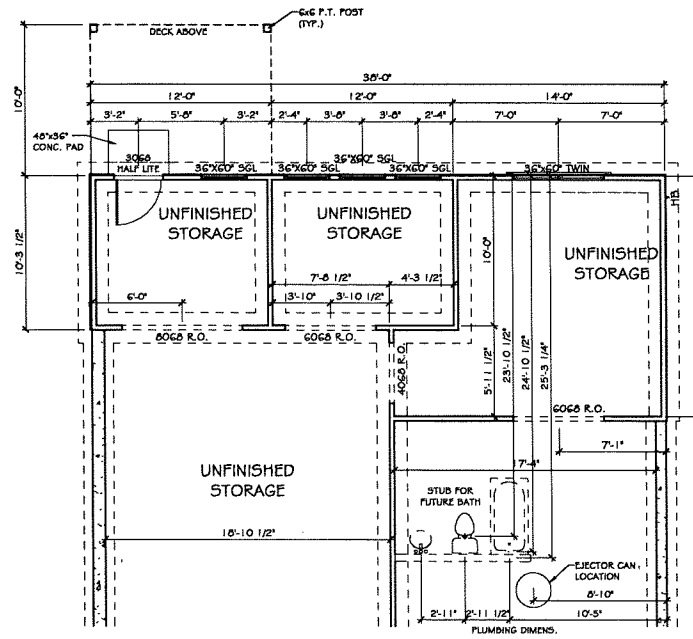

① Opt. Sunroom Basement Plan
1/8" = 1'-0"

Revisions:		
#	DATE	REMARKS

Project Name (Base Plan/Residence):

Elevation Code: Slab
Foundation: LH
Drive Side: LH
Name of Project/Residence:

BASE PLAN

Neighborhood/Lot #: LOT # COMMUNITY

Plan Name: EDISON

Plot Scale: AS NOTED

Created Date: 08/09/17

Plot Date: 05/15/20

Drawn by: Matt Shelton

OPTIONS

PATRICK MALLOY

COMMUNITIES

4770 S. ATLANTA RD., STE. 100, ATLANTA, GA 30339 770.632.6376

SHEET:

AD1.0.3

[illegible][illegible]

Project Name	Date	Status
BASE PLAN		

Elevation Code: -

Foundation: Slab

Drive Side: LH

See plans and section drawings.

Neighborhood/Lot #: **LOT # & COMMUNITY**
Plan Name: **EDISON**

Plot Scale:
AS NOTED

Created Date:
08/09/17

Plot Date:
07/07/20

Drawn by:
Matt Shelton

OPTIONS

PATRICK MALLOY
COMMUNITIES
4770 S. ATLANTA RD., STE. 100, ATLANTA, GA 30339 770.635.6376

SHEET:
AD1.0.6