

FEB 05 2021

JEFFERSON

BASE PLAN

CITY OF SNELLVILLE
PLANNING & DEVELOPMENT

Sheet Number	Sheet Name
AO.0.0	COVER SHEET
AO.0.2	GENERAL NOTES
A1.0.0	FRONT & LEFT ELEVATION - A
A1.0.1	REAR & RIGHT ELEVATION - A
A1.0.2	ROOF PLAN - A
A1.1.0	SLAB FOUNDATION PLAN - A
A1.2.0	FIRST FLOOR PLAN - A
A2.0.0	FRONT & LEFT ELEVATION - B
A2.0.1	REAR & RIGHT ELEVATION - B
A2.0.2	ROOF PLAN - B
A2.1.0	SLAB FOUNDATION PLAN - B
A2.2.0	FIRST FLOOR PLAN - B
A3.0.0	FRONT & LEFT ELEVATION - C
A3.0.1	REAR & RIGHT ELEVATION - C
A3.0.2	ROOF PLAN - C
A3.1.0	SLAB FOUNDATION PLAN - C
A3.2.0	FIRST FLOOR PLAN - C
A4.0.0	FRONT & LEFT ELEVATION - D
A4.0.1	REAR & RIGHT ELEVATION - D
A4.0.2	ROOF PLAN - D
A4.1.0	SLAB FOUNDATION PLAN - D
A4.2.0	FIRST FLOOR PLAN - D
AD1.0.0	BASEMENT FOUNDATION PLAN
E1.0.0	BASEMENT ELECTRICAL PLAN
E1.1.0	FIRST FLOOR ELECTRICAL PLAN
H2.0.0	ELEVATIONS - B
H2.0.1	1ST FLOOR - B
H4.0.0	ELEVATIONS - D
H4.0.1	1ST FLOOR - D



1. 2012 INTERNATIONAL RESIDENTIAL CODE, WITH 2014 GEORGIA AMENDMENTS.
2. NATIONAL DESIGN SPECIFICATION FOR WOOD CONSTRUCTION.
3. ACI 318, BUILDING CODE FOR REINFORCED CONCRETE.
4. A.I.S.C. MANUAL OF STEEL CONSTRUCTION
5. T.P.I. SPECIFICATION FOR THE DESIGN, MANUFACTURE AND HANDLING OF WOOD TRUSSES.

AREA	SQ. FT.
First Floor - A	2064 SF
TOTAL - A - HEATED	2064 SF
2 Car Garage - A	410 SF
Front Covered Porch - A	179 SF
Rear Covered Patio - A	250 SF
TOTAL - A - UNHEATED	840 SF
First Floor - B	2064 SF
TOTAL - B - HEATED	2064 SF
2 Car Garage - B	410 SF
Front Covered Porch - B	119 SF
Rear Covered Patio - B	250 SF
TOTAL - B - UNHEATED	780 SF
First Floor - C	2097 SF
TOTAL - C - HEATED	2097 SF
2 Car Garage - C	410 SF
Front Covered Porch - C	110 SF
Rear Covered Patio - C	250 SF
TOTAL - C - UNHEATED	771 SF
First Floor - D	2064 SF
TOTAL - D - HEATED	2064 SF
2 Car Garage - D	410 SF
Front Covered Porch - D	190 SF
Rear Covered Patio - D	250 SF
TOTAL - D - UNHEATED	850 SF
Unfinished Basement	2004 SF
TOTAL - OPTIONAL UNHEATED	2004 SF

[illegible][illegible]

Elevation Code: -
Foundation: Slab
Drive Side: LH

Project Name (Base Plans/Residence):

BASE PLAN

Neighborhood/Lot #:
LOT # & COMMUNITY

Plan Name: JEFFERSON

Plot Scale:
AS NOTED

Created Date:
12/31/19

Plot Date:
01/31/20


Drawn by:
Matt Shelton

COVER SHEET

PATRICK MALLOY
C O M M U N I T I E S
4770 S. ATLANTA RD., STE. 100, ATLANTA, GA 30339 770.932.6376

SHEET:

AO.O.O

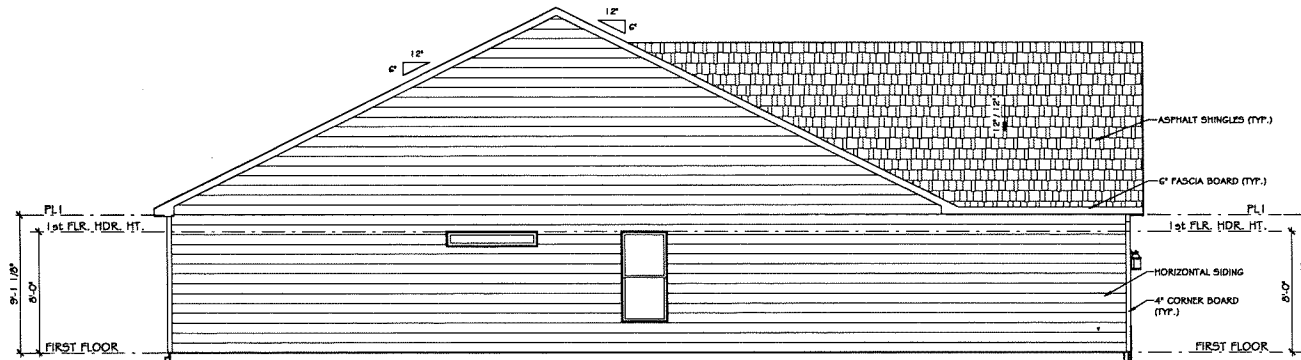

② LEFT ELEVATION - A
1/8" = 1'-0"



① FRONT ELEVATION - A
1/8" = 1'-0"

REVISIONS:	
#	DATE

Project Name (Base Plans/Residence):

Elevation Code: Slab
Foundation: LH
Drive Side: LH

Neighborhood Lot #: LOT # COMMUNITY

Plan Name: JEFFERSON

Plot Scale: AS NOTED

Created Date: 12/31/19

Plot Date: 01/31/20

Drawn by: Matt Shelton


FRONT & LEFT ELEVATION - A

PATRICK MALLOY


COMMUNITIES

4770 S. ATLANTA RD., STE. 100, ATLANTA, GA 30339 770.632.6576

SHEET: A1.0.0

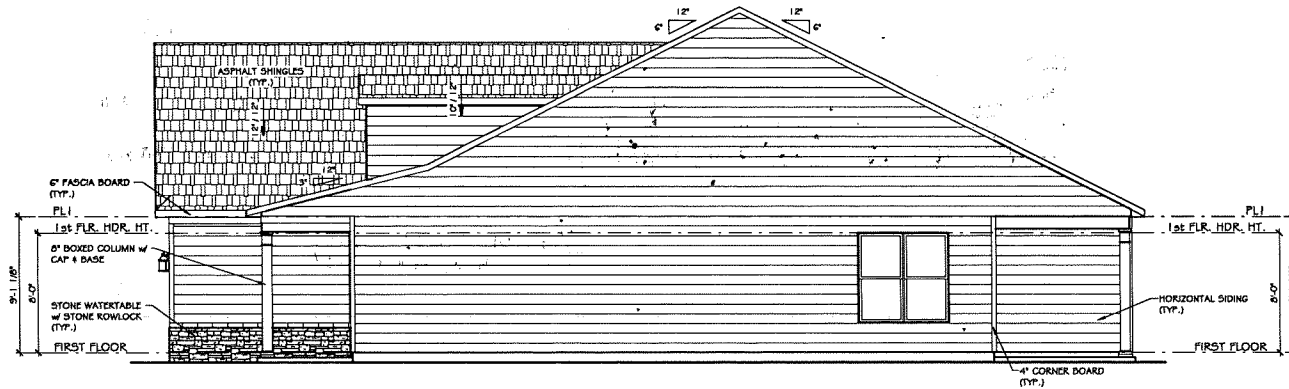

② RIGHT ELEVATION - A
1/8" = 1'-0"

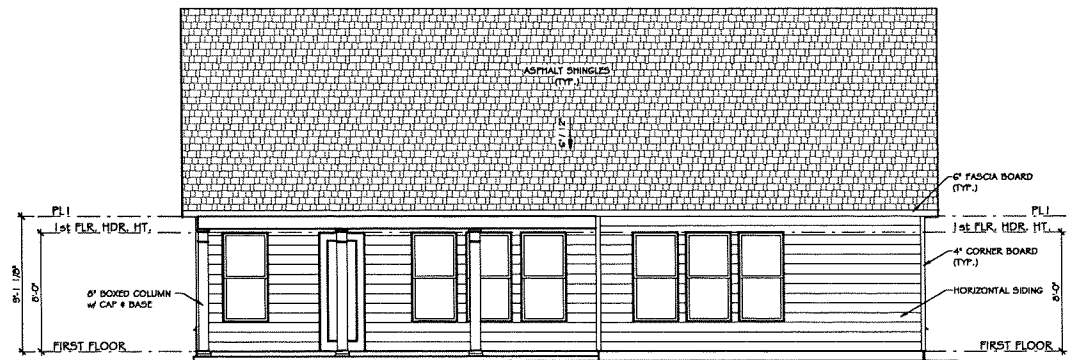

① REAR ELEVATION - A
1/8" = 1'-0"

Revisions:

#	DATE	REMARKS

Project Name: (Base Trans/Residence)

BASE PLAN

Elevation Code: Slab
Foundation: LH
Drive Side: LH
Notes: (See General Notes)

Neighborhood/Lot #: LOT # COMMUNITY

Plan Name: JEFFERSON


Plot Scale: AS NOTED
Created Date: 12/31/19
Plot Date: 01/31/20
Drawn by: Matt Shelton

REAR & RIGHT ELEVATION - A

PATRICK MALLOY
COMMUNITIES
4770 S. ATLANTA RD., STE. 100, ATLANTA, GA 30339 770.632.6376

SHEET:

A1.0.1

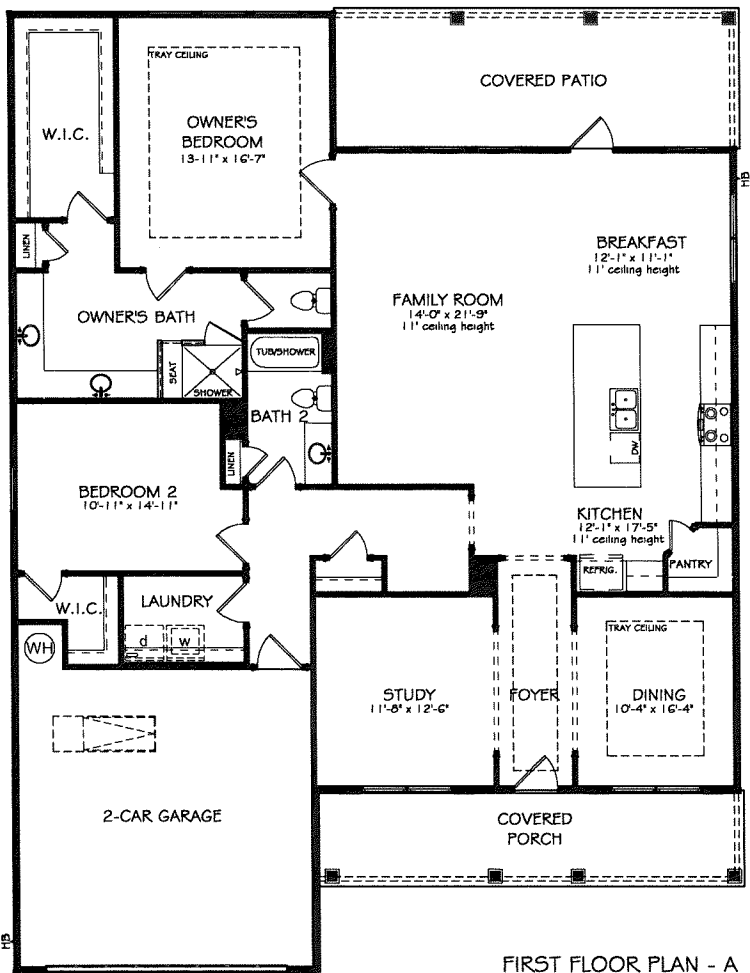




Revisions:		
#	DATE	REMARKS

Project Name (Base Plan/Revised):		Elevation Code:	Slab
BASE PLAN		Foundation:	LH
Neighborhood #:		Drive Side:	
LOT # COMMUNITY			
Plan Name:		JEFFERSON	


Plot Scale:	AS NOTED
Created Date:	12/31/19
Plot Date:	07/23/19
Drawn by:	Matt Shelton

1ST FLOOR - A	PATRICK MALLOY	COMMUNITIES	4770 S. ATLANTA RD., STE. 100, ATLANTA, GA 30339 770.632.6376
SHEET:			
H1.O.1			

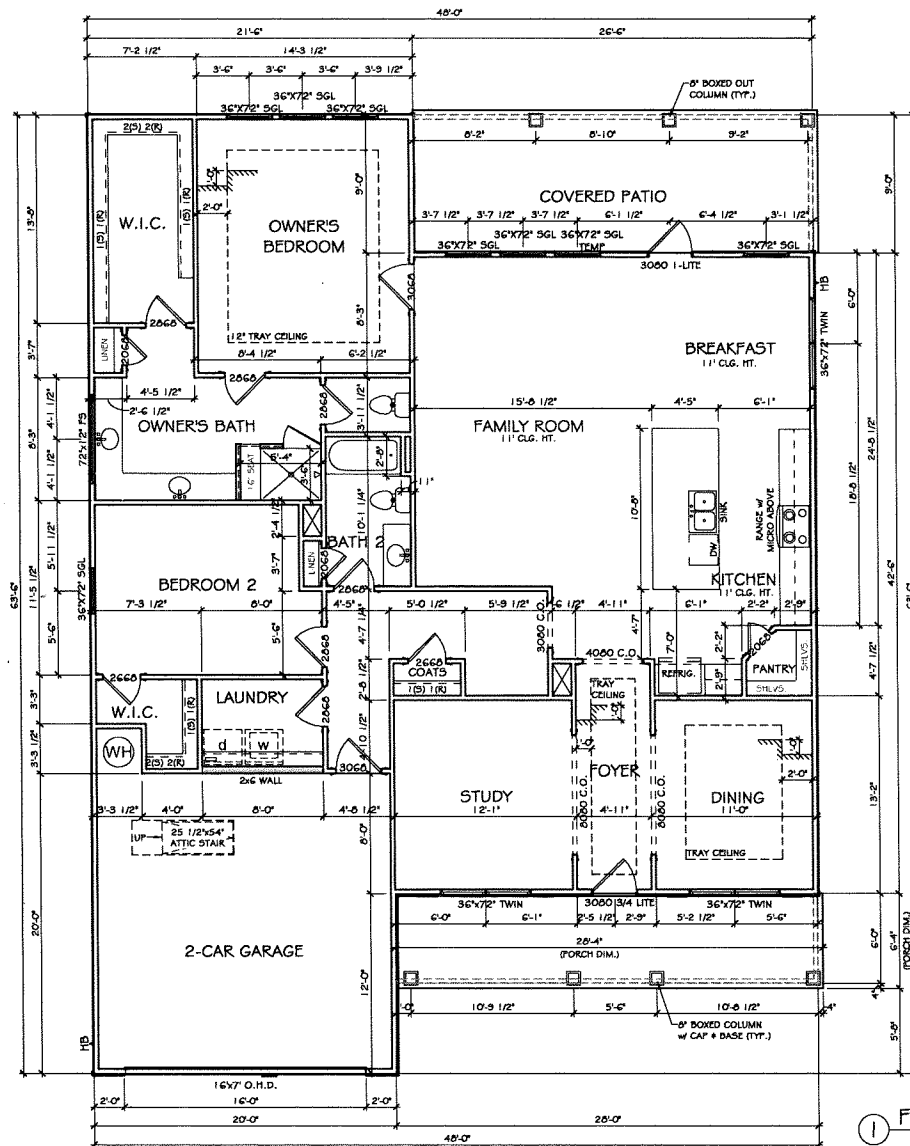


  

SHEET:
2.0.0

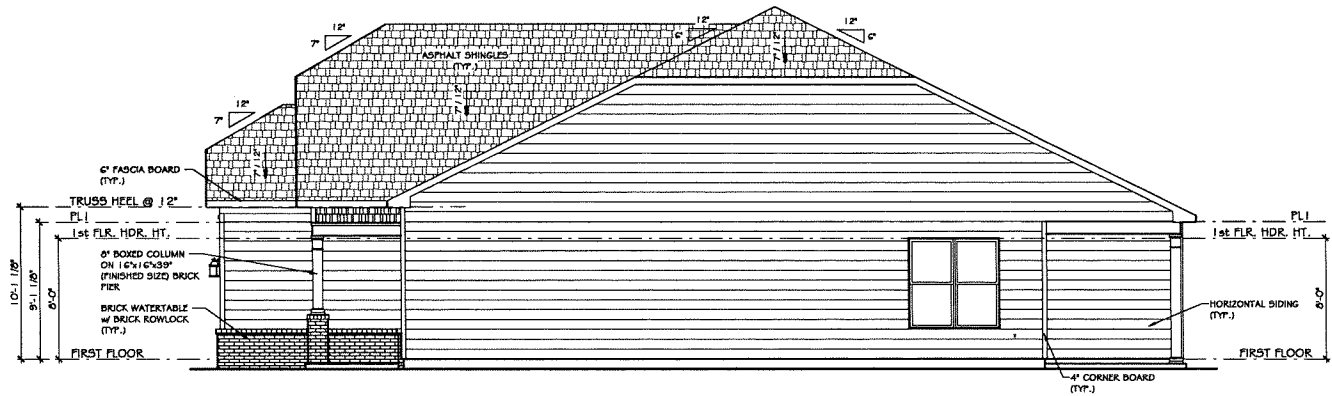

② RIGHT ELEVATION - B
1/8" = 1'-0"

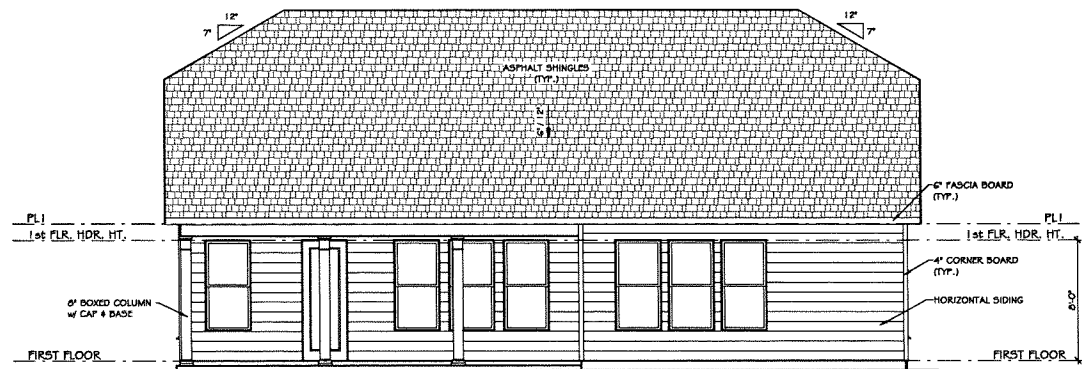


① REAR ELEVATION - B
1/8" = 1'-0"

Revisions:		
#	DATE	REMARKS

Project Name (Base Transference):	
BASE PLAN	
Elevation Code: Slab	LI
Foundation: Drive Side:	LI
Neighborhood #:	
LOT # COMMUNITY	
Plan Name: JEFFERSON	

Plot Scale:	A5 NOTED
Created Date:	12/31/19
Plot Date:	01/31/20
Drawn by:	Matt Shelton

REAR & RIGHT ELEVATION - B	PATRICK MALLOY COMMUNITIES 4770 S. ATLANTA RD., STE. 100, ATLANTA, GA 30339 770.632.6376	
SHEET:		
A2.0.1		

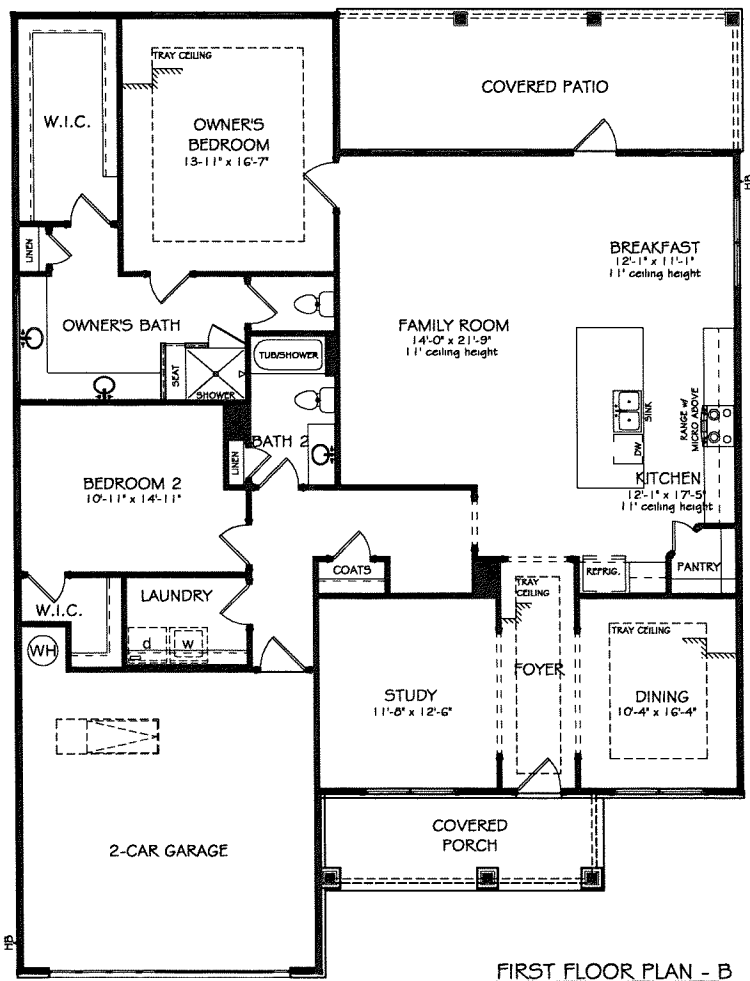

FIRST FLOOR PLAN - B

Revisions:

#	DATE	REMARKS
1	12/31/19	AS NOTED
2		
3		
4		
5		
6		
7		
8		
9		
10		

BASE PLAN

Project Name (Base Plan/Residence):

Neighborhood #:

LOT # COMMUNITY

Plan Name: JEFFERSON

Elevation Code: Slab LH

Foundation: LH

Drive Side: LH

SCHEMATIC OF HOUSE

Plot Scale: AS NOTED

Created Date: 12/31/19

Plot Date: 06/04/20

Drawn by: Matt Shelton

1ST FLOOR - B

PATRICK MALLOY


COMMUNITIES

4770 S. ATLANTA RD., STE. 100, ATLANTA, GA 30339 770.632.6376

SHEET:

H2.O.1

12/31/19

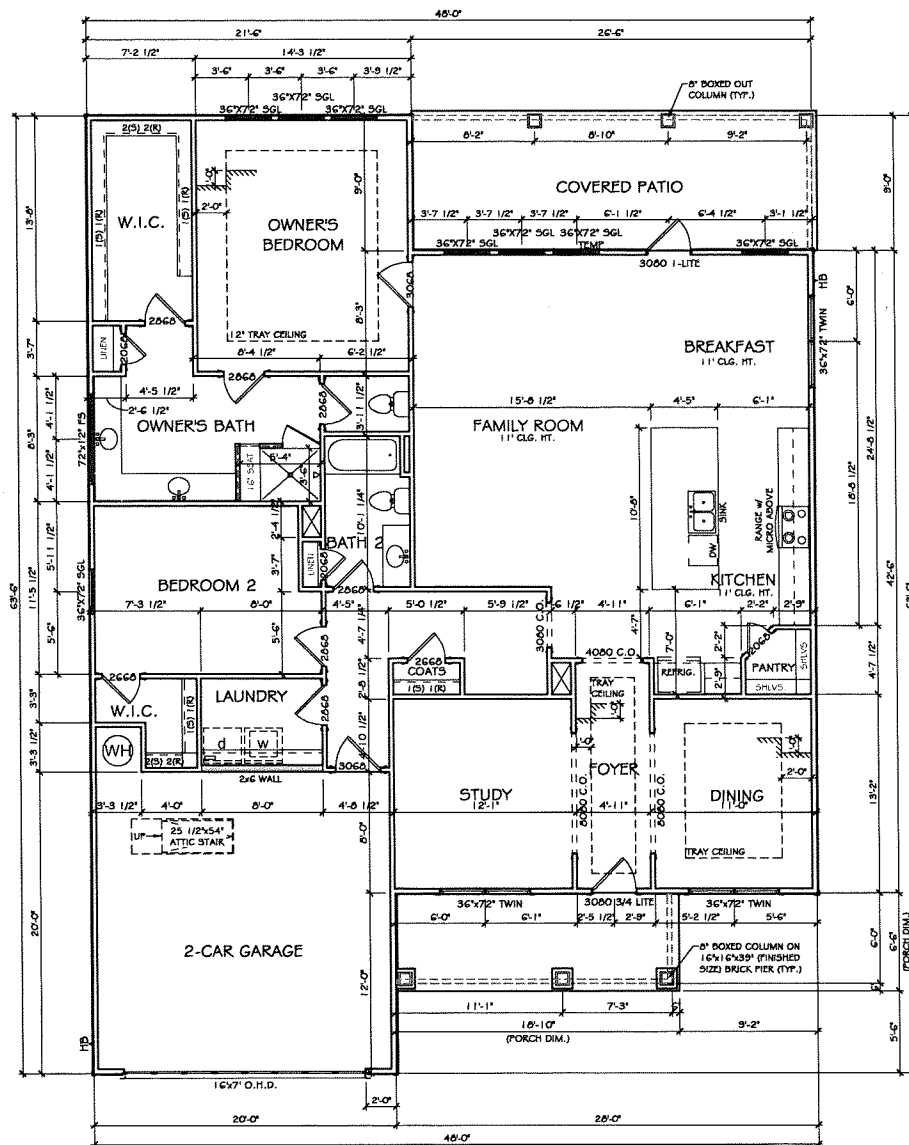

① First Floor Plan - B
1/8" = 1'-0"

[illegible]

Project Name (Base Plans/Residence):

BASE PLAN

Neighborhood/Lot #:

Neighborhood/Lot #:
LOT # & COMMUNITY

Plan Name: JEFFERSON

Elevation Code:-

Foundation:

006 894 A 03306 A 10-611478

Plot Scale:

AS NOTED

Created Date:

12/31/19

Plot Date:

01/31/20

Drawn by:

Matt Shelton


FIRST FLOOR PLAN - B

PATRICK MALLOY


COMMUNITIES
4770 S. ATLANTA RD., STE. 100, ATLANTA, GA 30339 770.832.6376

SHEET:

A2.2.0

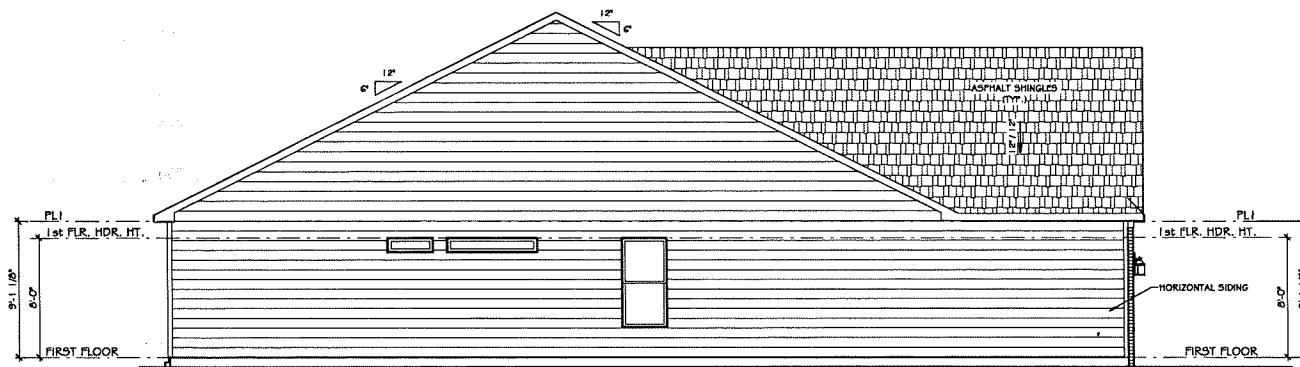

② LEFT ELEVATION - C
1/8" = 1'-0"

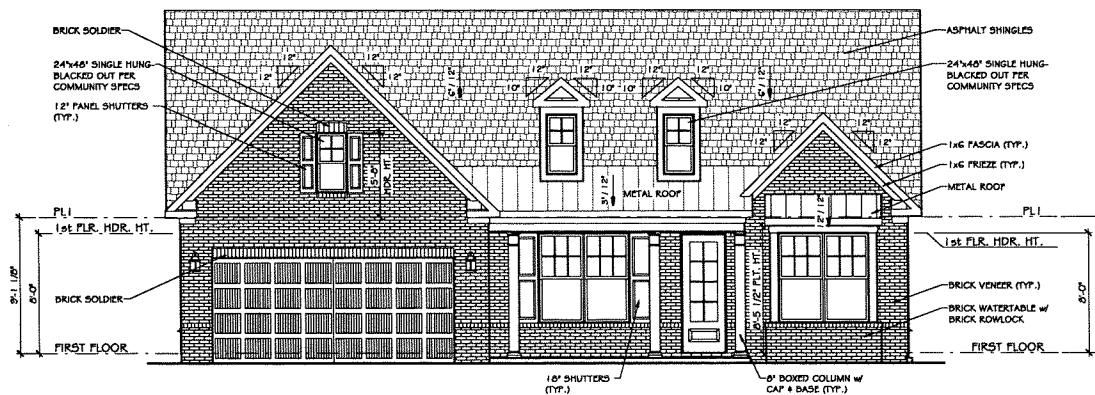

① FRONT ELEVATION - C
1/8" = 1'-0"

REVISIONS:		
#	DATE	REMARKS


Project Name: (Base Plans/Residence)
Elevation Code: Slab
Foundation: L1
Drive Side: L1
Neighborhood/Lot #: LOT # COMMUNITY
Plan Name: JEFFERSON

BASE PLAN
Neighborhood/Lot #: LOT # COMMUNITY
Plan Name: JEFFERSON

Plot Scale: AS NOTED
Created Date: 12/31/19
Plot Date: 01/31/20
Drawn by: Matt Shelton

FRONT & LEFT ELEVATION - C
PATRICK MALLOY
COMMUNITIES
4770 S. ATLANTA RD., STE. 100, ATLANTA, GA 30339 770.432.6376

SHEET:
A3.0.0

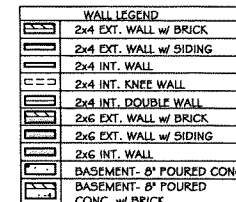

① First Floor Plan - C
1/8" = 1'-0"

[illegible]

Project Name (Base Plans/Residence):

Project Name (Base Plan)

Neighborhood at #:

Elevation Code: -

Neighborhood/Lot #:
LOT # 4 COMMUNITY

Drive Side: LH

Plan Name: JEFFERSON

Plot Scale:
AS NOTED
Created Date:
12/31/19
Plot Date:
01/31/20

Drawn by:
Matt Shelton

 
 
FIRST FLOOR PLAN - C


PATRICK MALLOY

COMMUNITIES


SHEET:

A3.2.0

A4.0.0

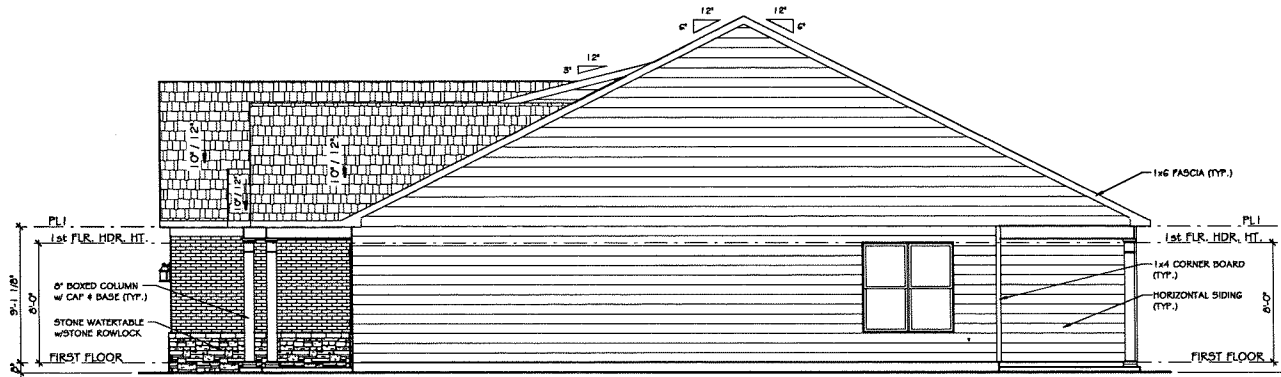

② RIGHT ELEVATION - D
1/8" = 1'-0"

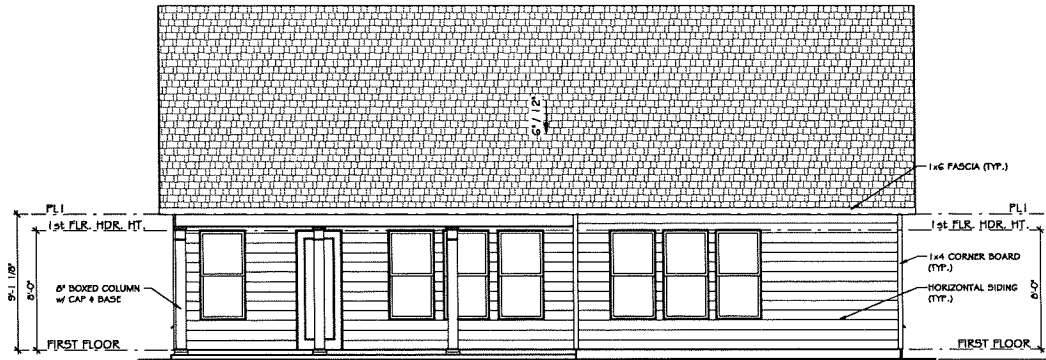

① REAR ELEVATION - D
1/8" = 1'-0"

Revisions:

#	DATE	REMARKS

Project Name: (Base Plans/Residence)

BASE PLAN

Elevation Code: Slab

Foundation: LH

Drive Side: LH

Foundation: (Base Plans/Residence)

Neighborhood/Lot #:

LOT # COMMUNITY

Plan Name: JEFFERSON

Plot Scale:

AS NOTED

Created Date:

12/31/19

Plot Date:

01/31/20

Drawn by:


Matt Shelton

REAR & RIGHT ELEVATION - D

PATRICK MALLOY
COMMUNITIES
4770 S. ATLANTA RD., STE. 100, ATLANTA, GA 30339 770.632.6376

SHEET:

A4.0.1

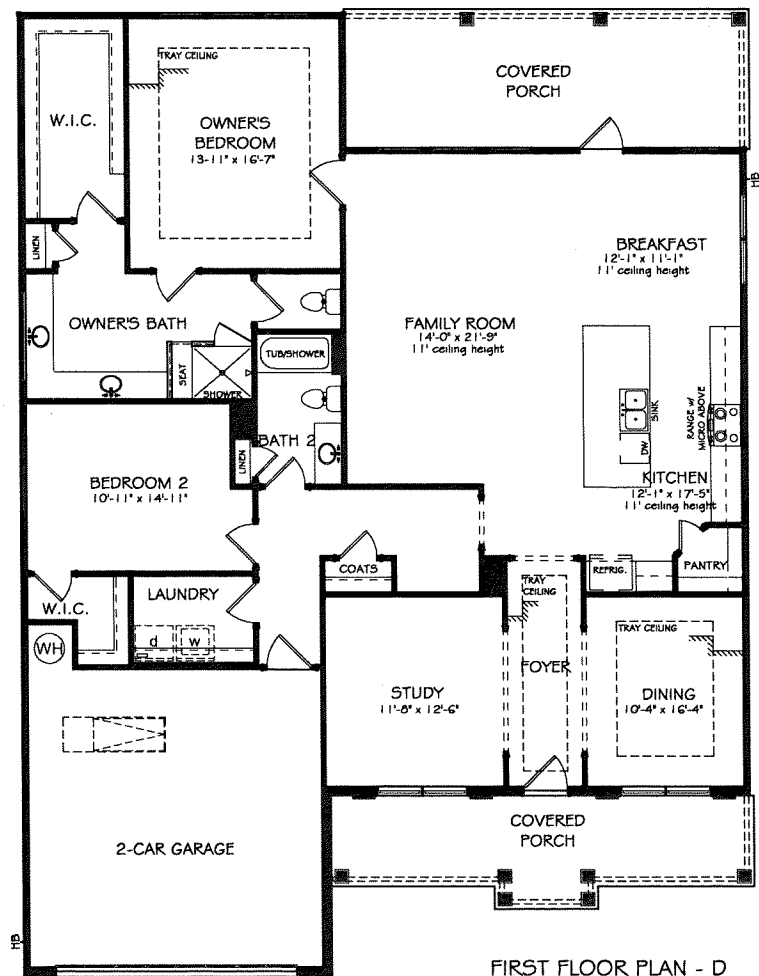


Revisions:		
#	DATE	REMARKS

Project Name: (Base Plans/Residence):	
BASE PLAN	
Elevation Code: Slab	LIH
Foundation: LH	LIH
Drive Side: LH	LIH
Plan Name: JEFFERSON	

Plot Scale:	AS NOTED
Created Date:	12/31/19
Plot Date:	06/04/20
Drawn by:	Matt Shelton

1ST FLOOR - D	PATRICK MALLOY	COMMUNITIES

SHEET:	H4.O.1
--------	--------

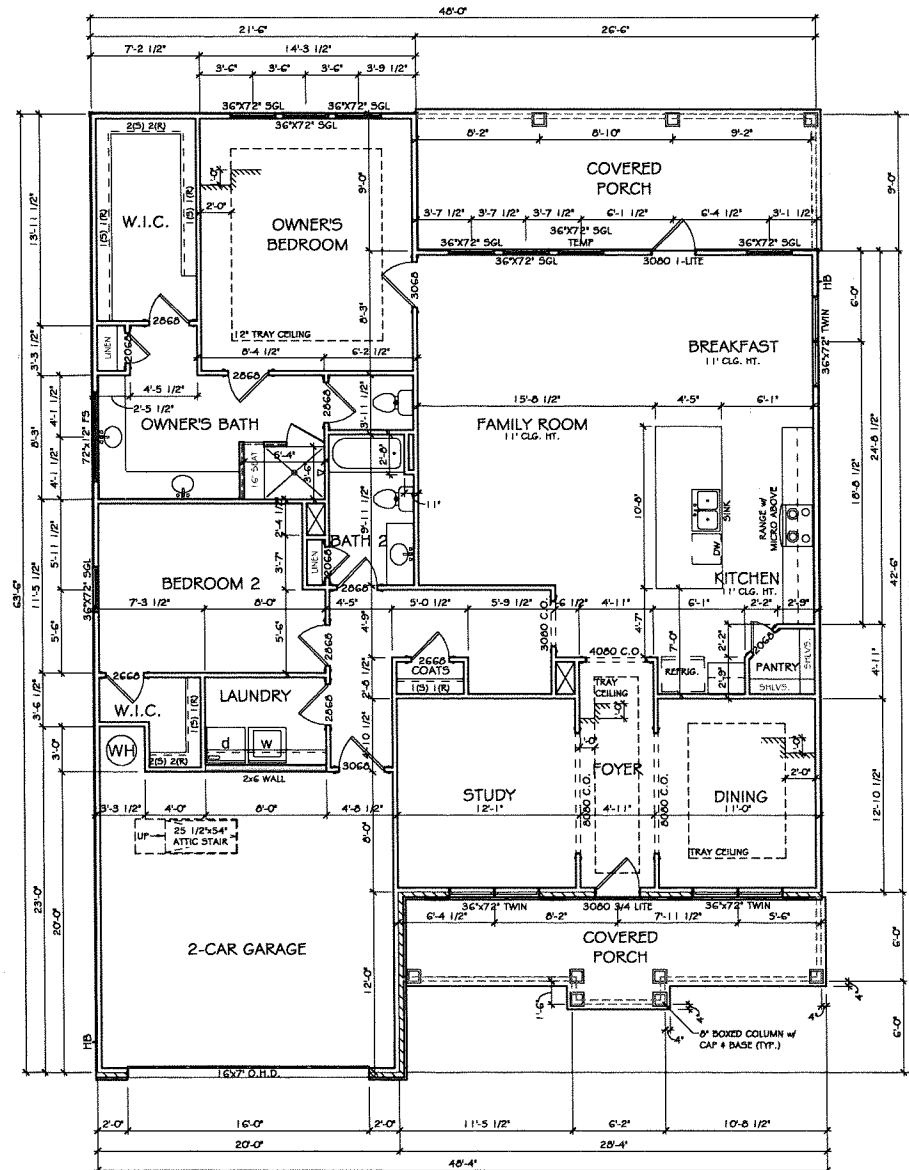

WALL LEGEND	
	2x4 EXT. WALL w/ BRICK
	2x4 EXT. WALL w/ SIDING
	2x4 INT. WALL
	2x4 INT. KNEE WALL
	2x4 INT. DOUBLE WALL
	2x6 EXT. WALL w/ BRICK
	2x6 EXT. WALL w/ SIDING
	2x6 INT. WALL
	BASEMENT- 8" POURED CONC. CONC. w/ BRICK

① First Floor Plan - D
1/8" = 1'-0"

Revisions:		
#	DATE	REMARKS

Project Name (Base Plan/Residence):	
BASE PLAN	Slab
Neighborhood/Lot #:	LI
Plan Name:	JEFFERSON

Plot Scale:	AS NOTED
Created Date:	12/31/19
Plot Date:	01/31/20
Drawn by:	Matt Shelton

FIRST FLOOR PLAN - D	PATRICK MALLOY
COMMUNITIES	
4770 S. ATLANTA RD., STE. 100, ATLANTA, GA 30339 770.632.6376	
SHEET:	
A4.2.0	