



LOCATION MAP  
SCALE: N.T.S.

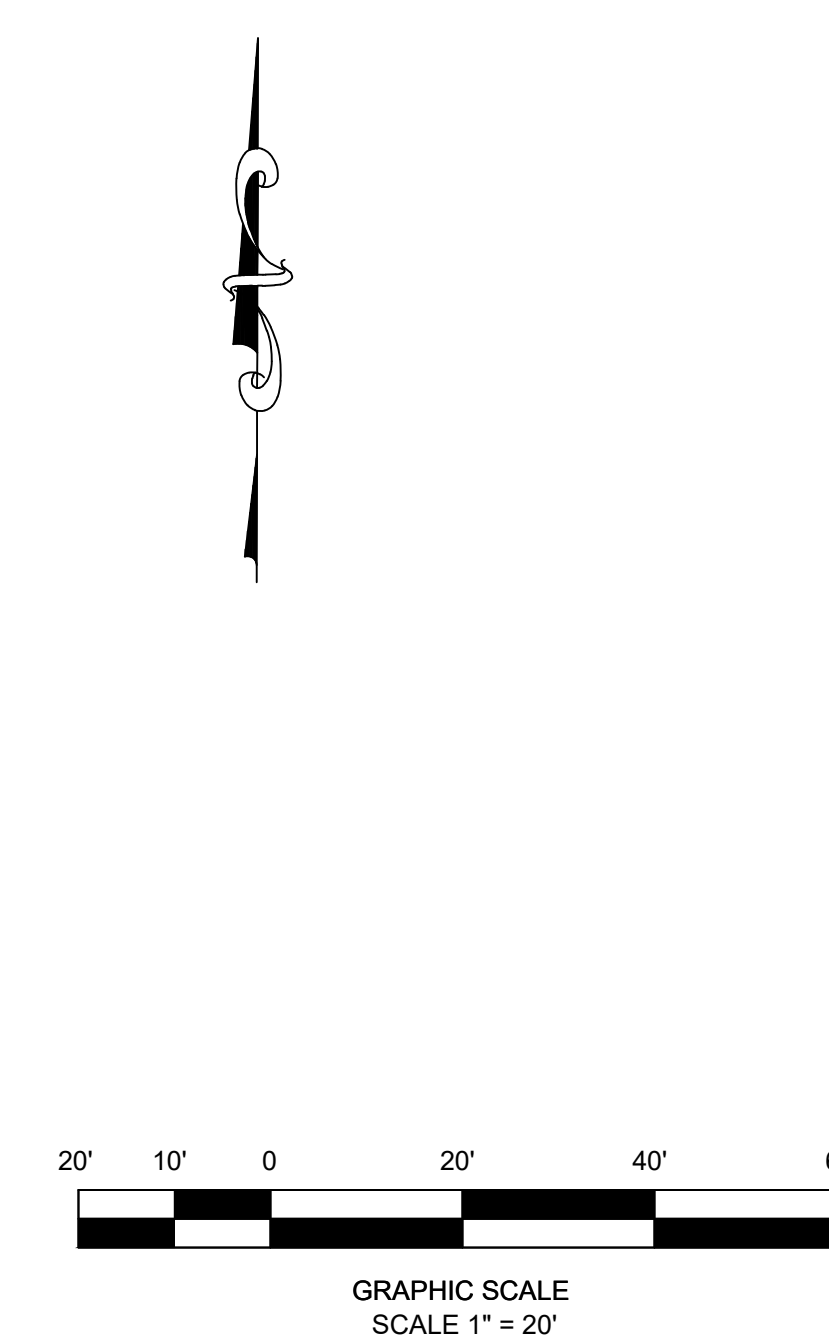

| REVISION BLOCK # | DATE     | DESCRIPTION                  |
|------------------|----------|------------------------------|
| 1                | 12/09/21 | VARIANCE SITE PLAN SUBMITTAL |

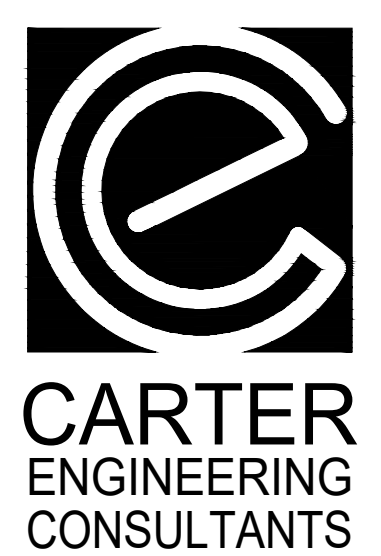

Carter Engineering Consultants, Inc.  
3651 Mars Hill Road, Suite 2000  
Wadkinsville, GA 30677  
P: 770.725.1200  
F: 770.725.1204  
www.carterengineering.net

**SITE DEVELOPMENT PLANS**  
FOR  
**RCG VENTURES, LLC**  
MAIN ST. E. SNELVILLE, GA 30078

PROJECT NAME:  
**RCG VENTURES LLC**

SHEET TITLE:  
**SITE PLAN AERIAL**

SHEET NUMBER:  
**4**

PROJECT NUMBER:  
**21055RCG**  
DATE:  
**12/09/21**